



ARCHITECTURAL WORKING DRAWINGS

PROJECT :
PROPOSED RESEARCH CENTRE FOR
Ananda Planet Green Force

At Ananda College
Colombo 10.

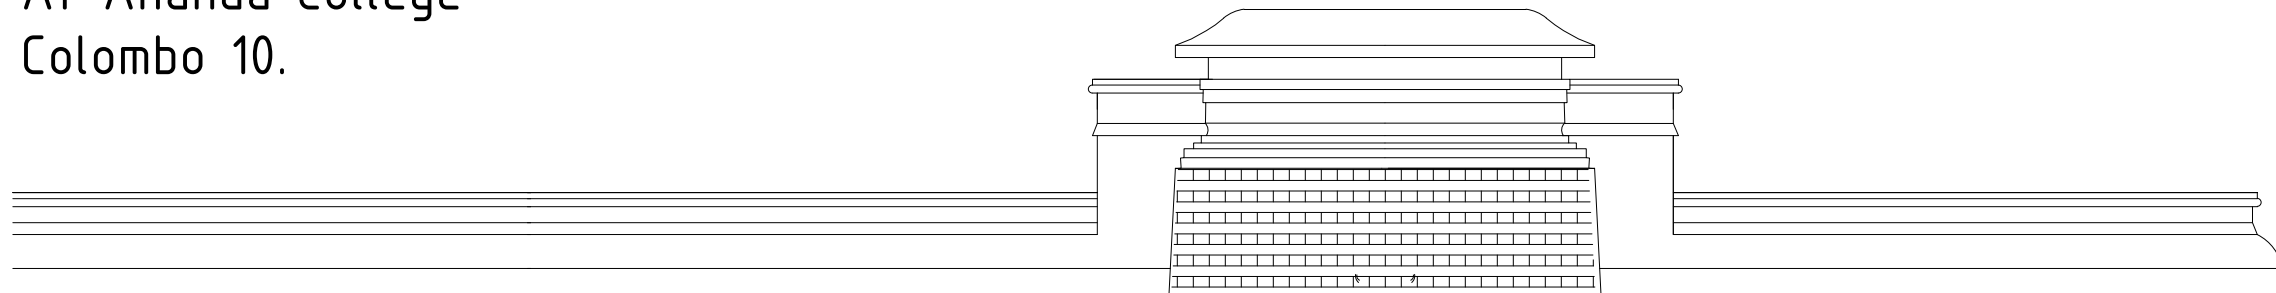

DATE : 28.05.2024

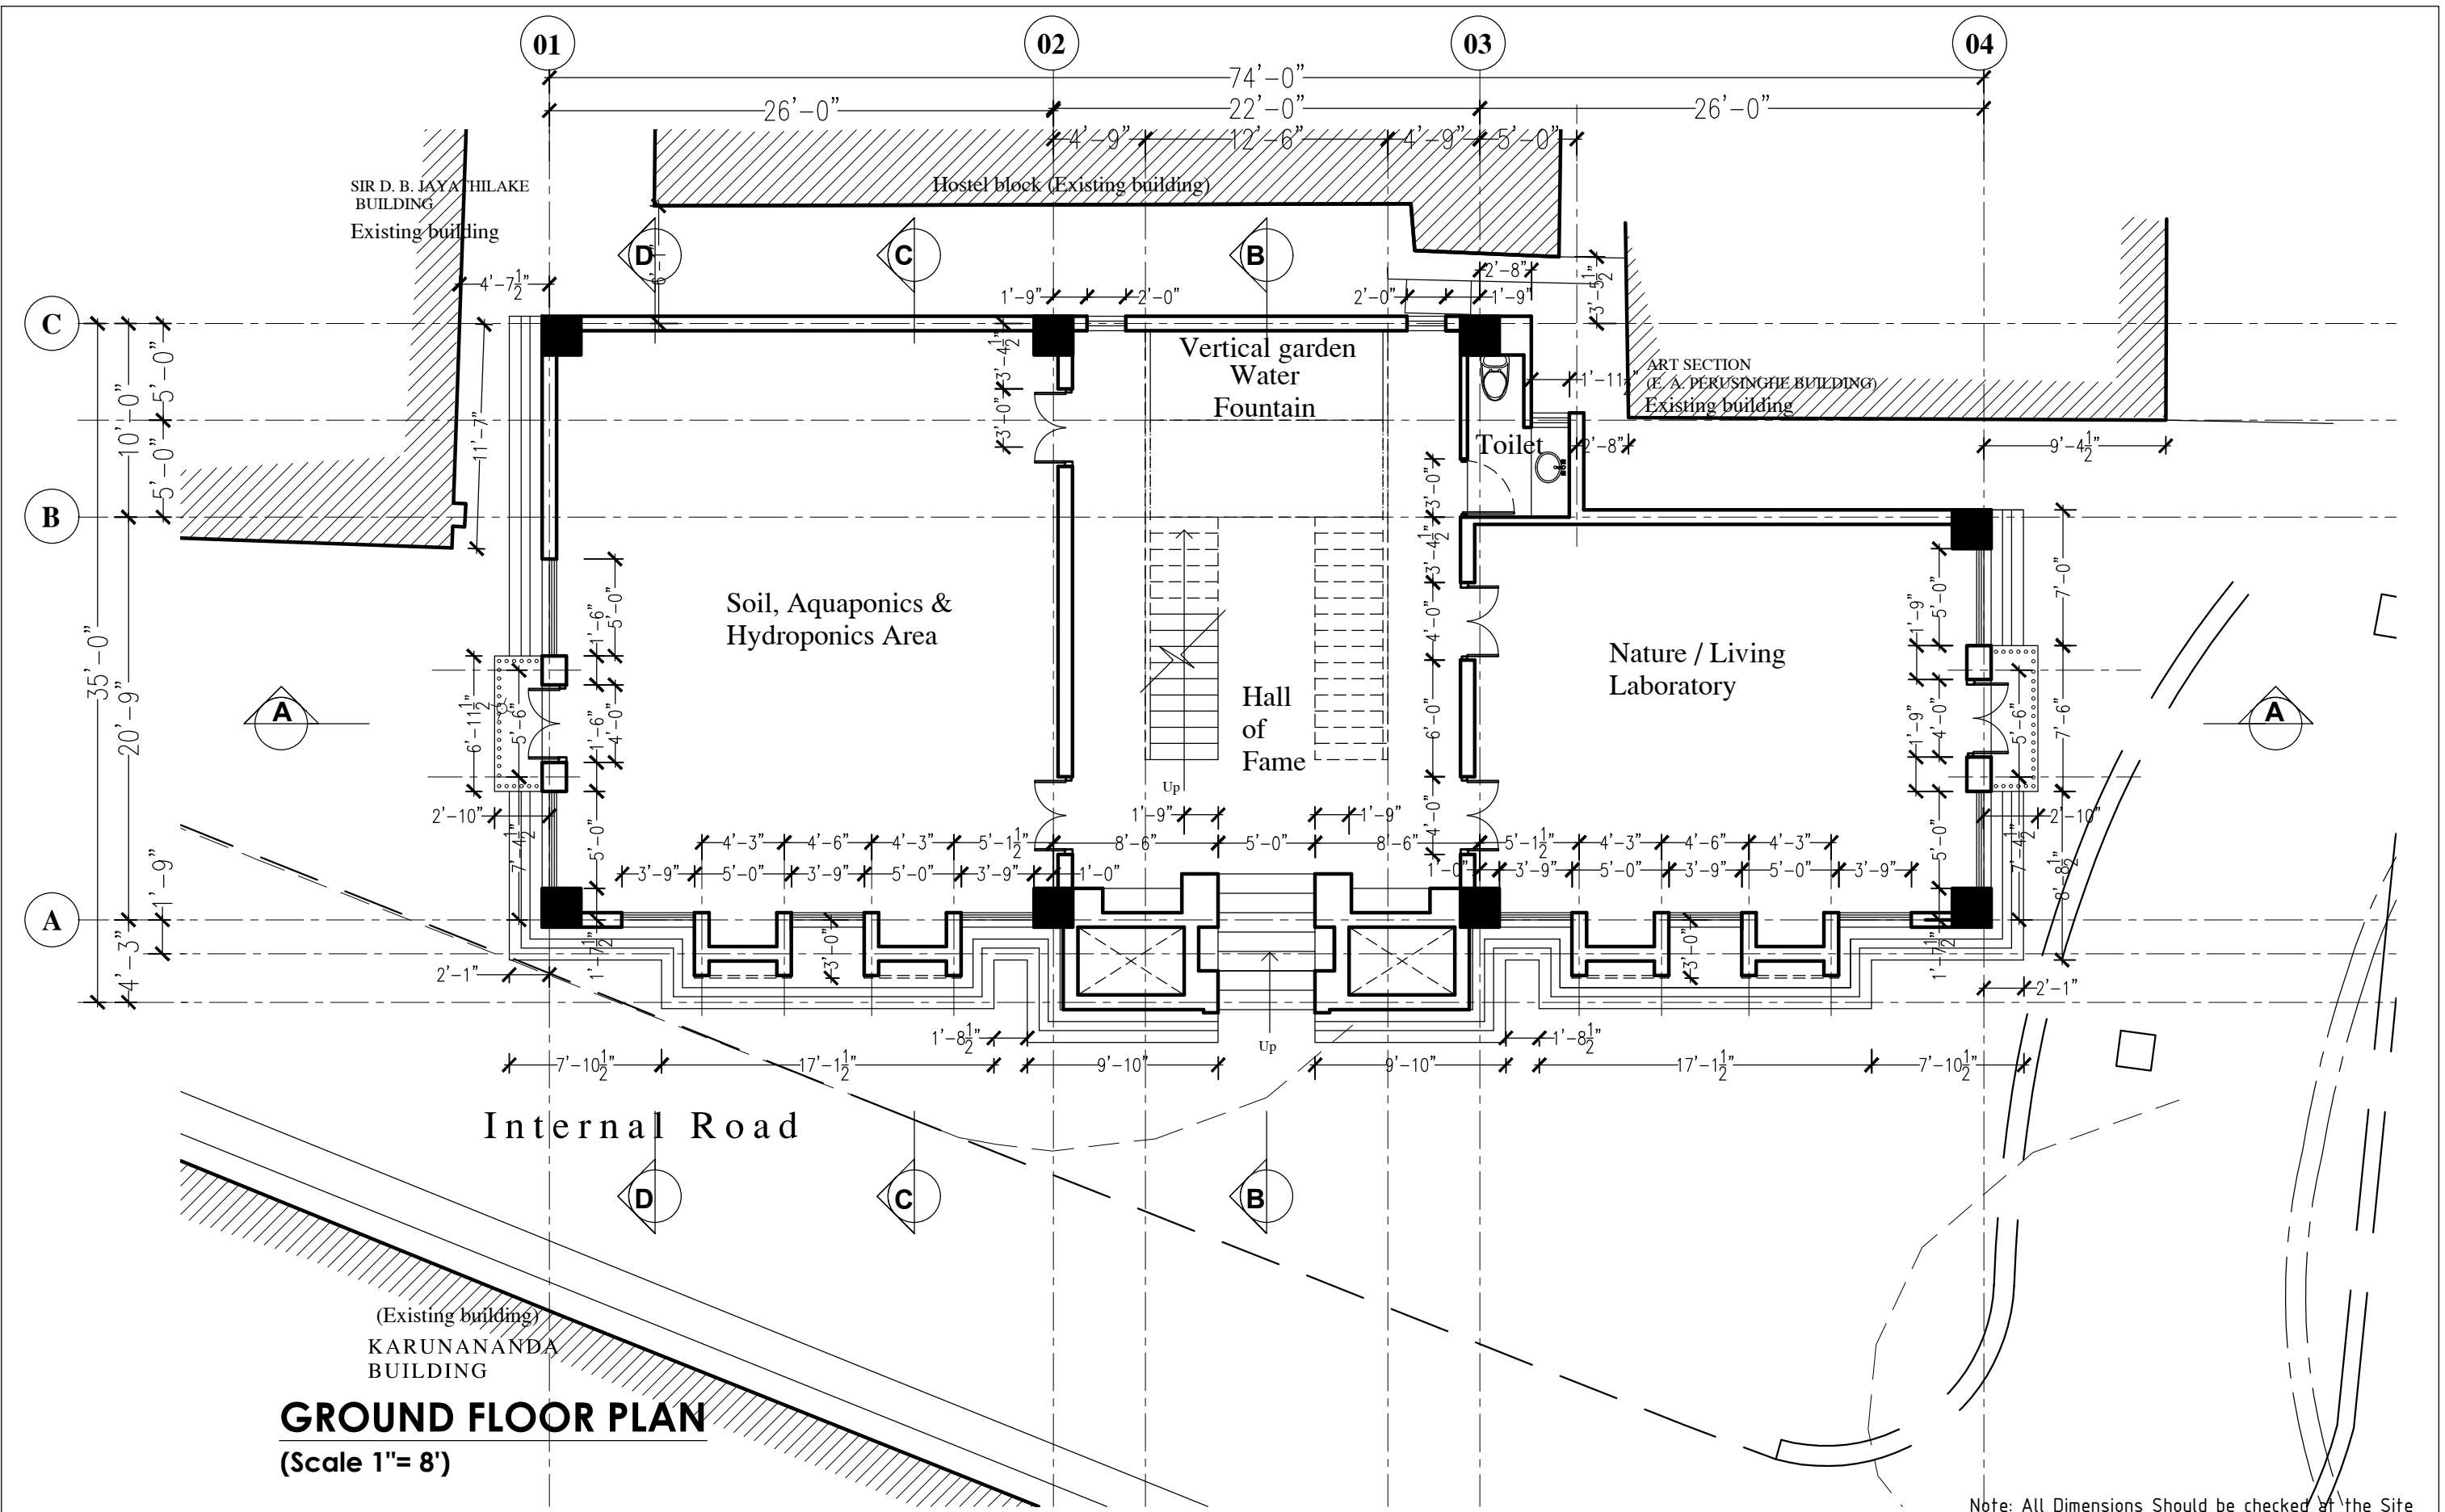

GROUND FLOOR PLAN
(Scale 1"= 8')

Note: All Dimensions Should be checked at the Site

PROJECT :
PROPOSED RESEARCH CENTRE FOR
Ananda Planet Green Force

At Ananda College
Colombo 10.


DRAWING TYPE :
CONSTRUCTION DRAWINGS

GROUND FLOOR-(Ananda Planet Green Force)

CONSULTANT ARCHITECT :
MUDITHA JAYAKODY ASSOCIATES (PVT.) LTD;
CHARTERED ARCHITECTS & CONSORTIUM CONSULTANTS.
NO.212, MAIN HOSPITAL ROAD,
KIRIBATHGODA.
PHONE : (0094)12910787 / FAX NO : (0094)12908294
E-mail : arc.mudithaa@gmail.com

CONSULTANT ENGINEER :

REV.	DATE.	DESCRIPTION	DRAWING NUMBER.
			MJA/And/A02
			SCALE : DATE : 28.05.2024
			SHEET NO. 02
			NTS

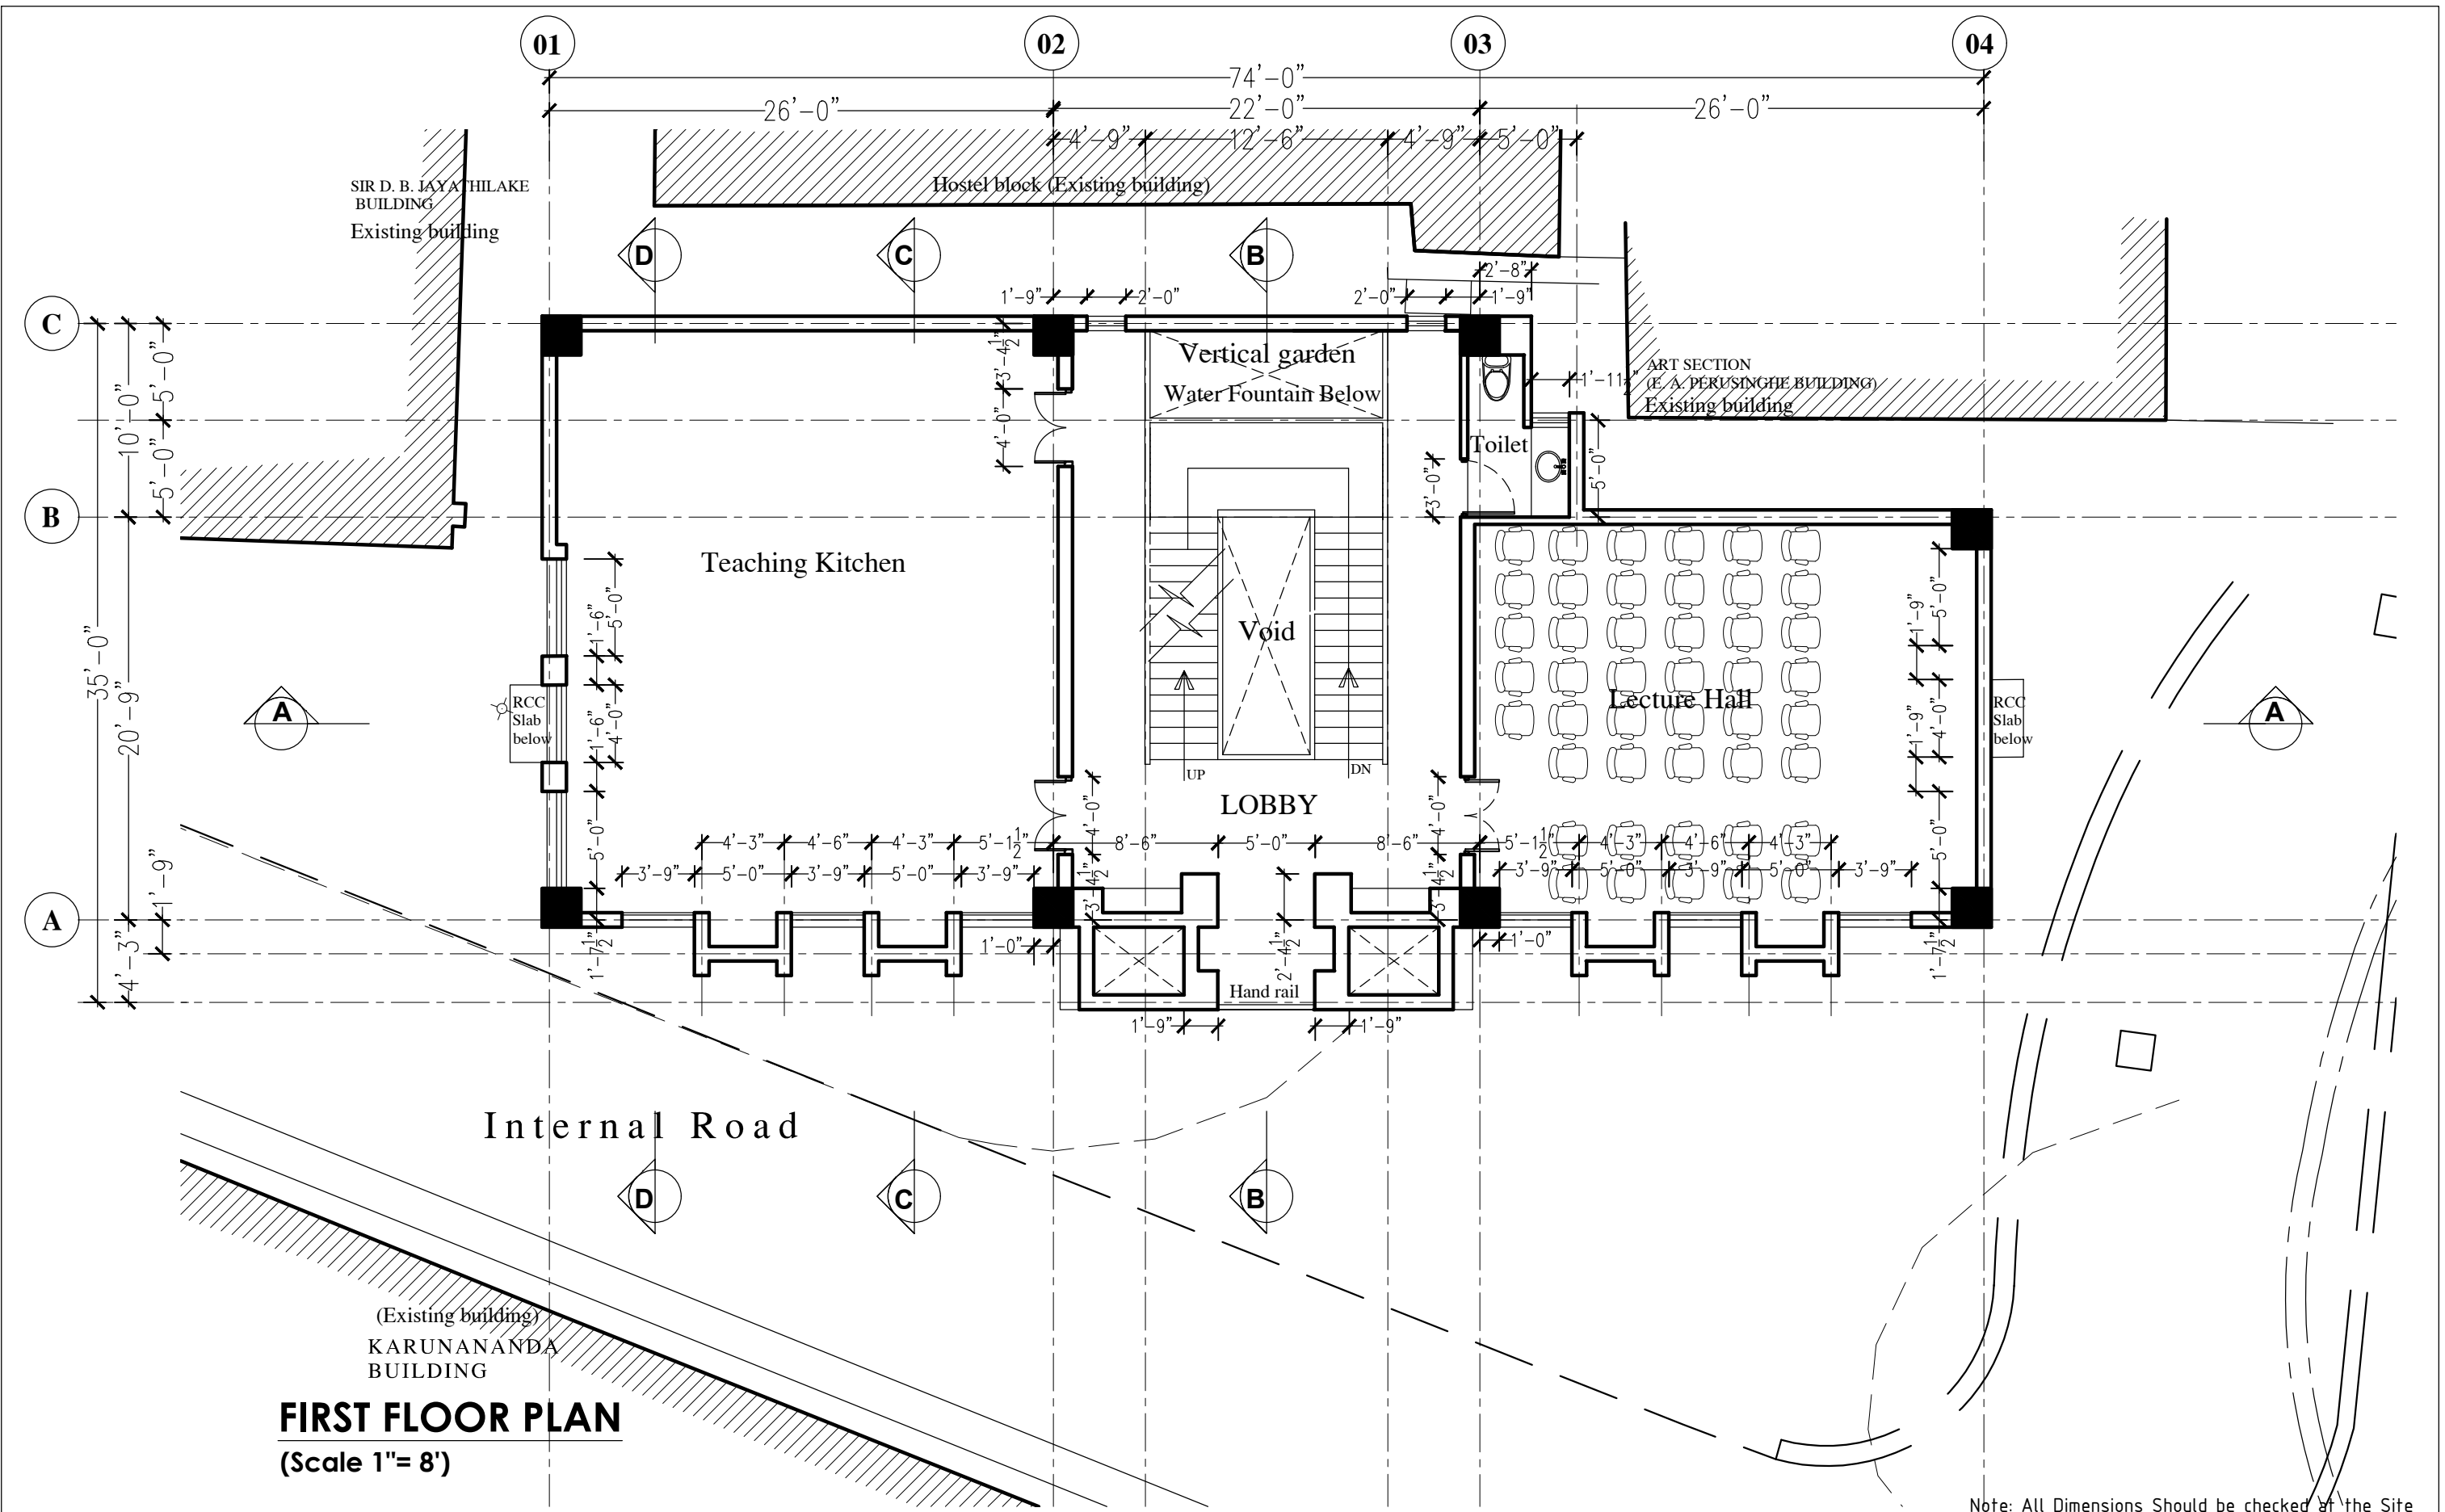

Note: All Dimensions Should be checked at the Site

PROJECT :
 PROPOSED RESEARCH CENTRE FOR
 Ananda Planet Green Force
 At Ananda College
 Colombo 10.


DRAWING TYPE :
 CONSTRUCTION DRAWINGS
 FIRST FLOOR-(Ananda Planet Green Force)

CONSULTANT ARCHITECT :
 MUDITHA JAYAKODY ASSOCIATES (PVT.) LTD;
 CHARTERED ARCHITECTS & CONSORTIUM CONSULTANTS.
 NO.212, MAIN HOSPITAL ROAD,
 KIRIBATHGODA.
 PHONE : (0094)12910787 / FAX NO : (0094)12908294
 E-mail : arc.mudithaa@gmail.com

CONSULTANT ENGINEER :

REV.	DATE.	DESCRIPTION	DRAWING NUMBER.
			MJA/And/A03
			SCALE : DATE : 28.05.2024
			SHEET NO. 03
			NTS

D:\Ananada college\GnF Planet_Print\03-Print-PlnGnF-1F_A3.dwg

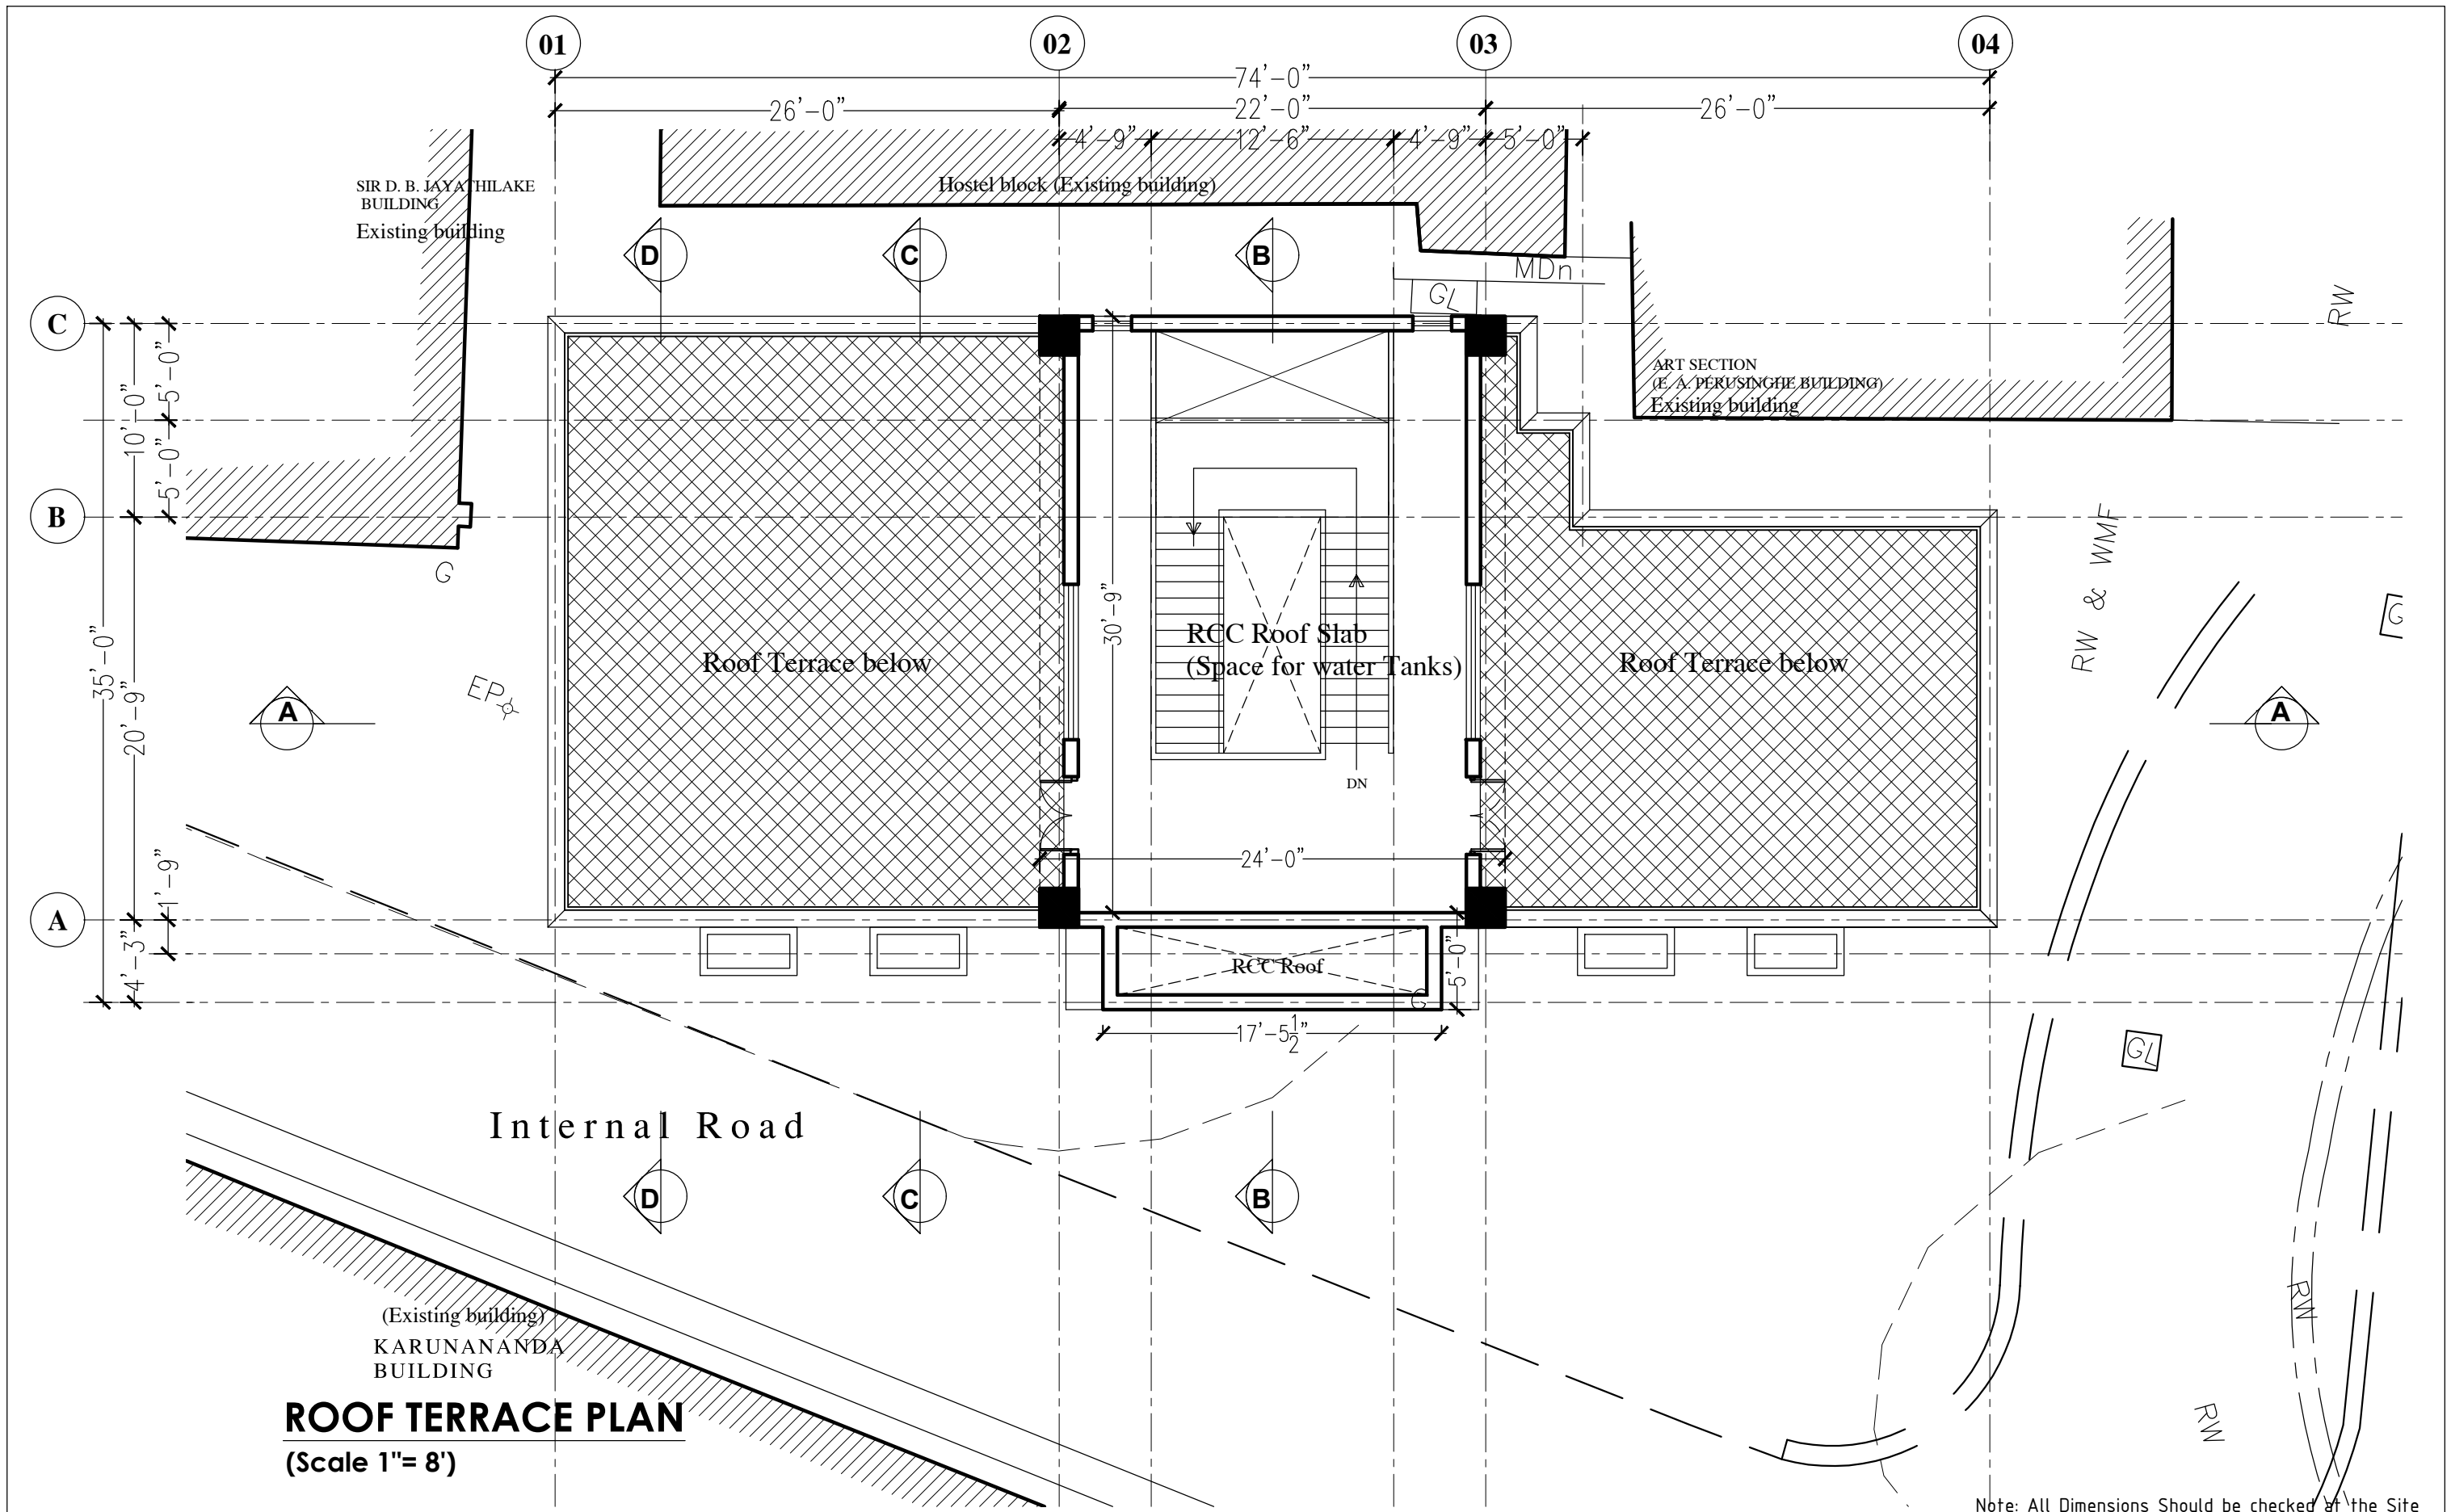

ROOF TERRACE PLAN
(Scale 1"= 8')

Note: All Dimensions Should be checked at the Site

PROJECT :
PROPOSED RESEARCH CENTRE FOR
Ananda Planet Green Force

At Ananda College
Colombo 10.

DRAWING TYPE :
CONSTRUCTION DRAWINGS

ROOF TERRACE-(Ananda Planet Green Force)

CONSULTANT ARCHITECT :
MUDITHA JAYAKODY ASSOCIATES (PVT.) LTD;
CHARTERED ARCHITECTS & CONSORTIUM CONSULTANTS.


NO.212, MAIN HOSPITAL ROAD,
KIRIBATHGODA.

PHONE : (0094)12910787 / FAX NO : (0094)12908294
E-mail : arc.mudithaa@gmail.com

CONSULTANT ENGINEER :

REV.	DATE.	DESCRIPTION	DRAWING NUMBER.
			MJA/And/A04
			SCALE : DATE : 28.05.2024
			SHEET NO. 04
			NTS

D:\Ananada college\GnF Planet_Print\04-Print-PlnGnF-RFT_A3.dwg

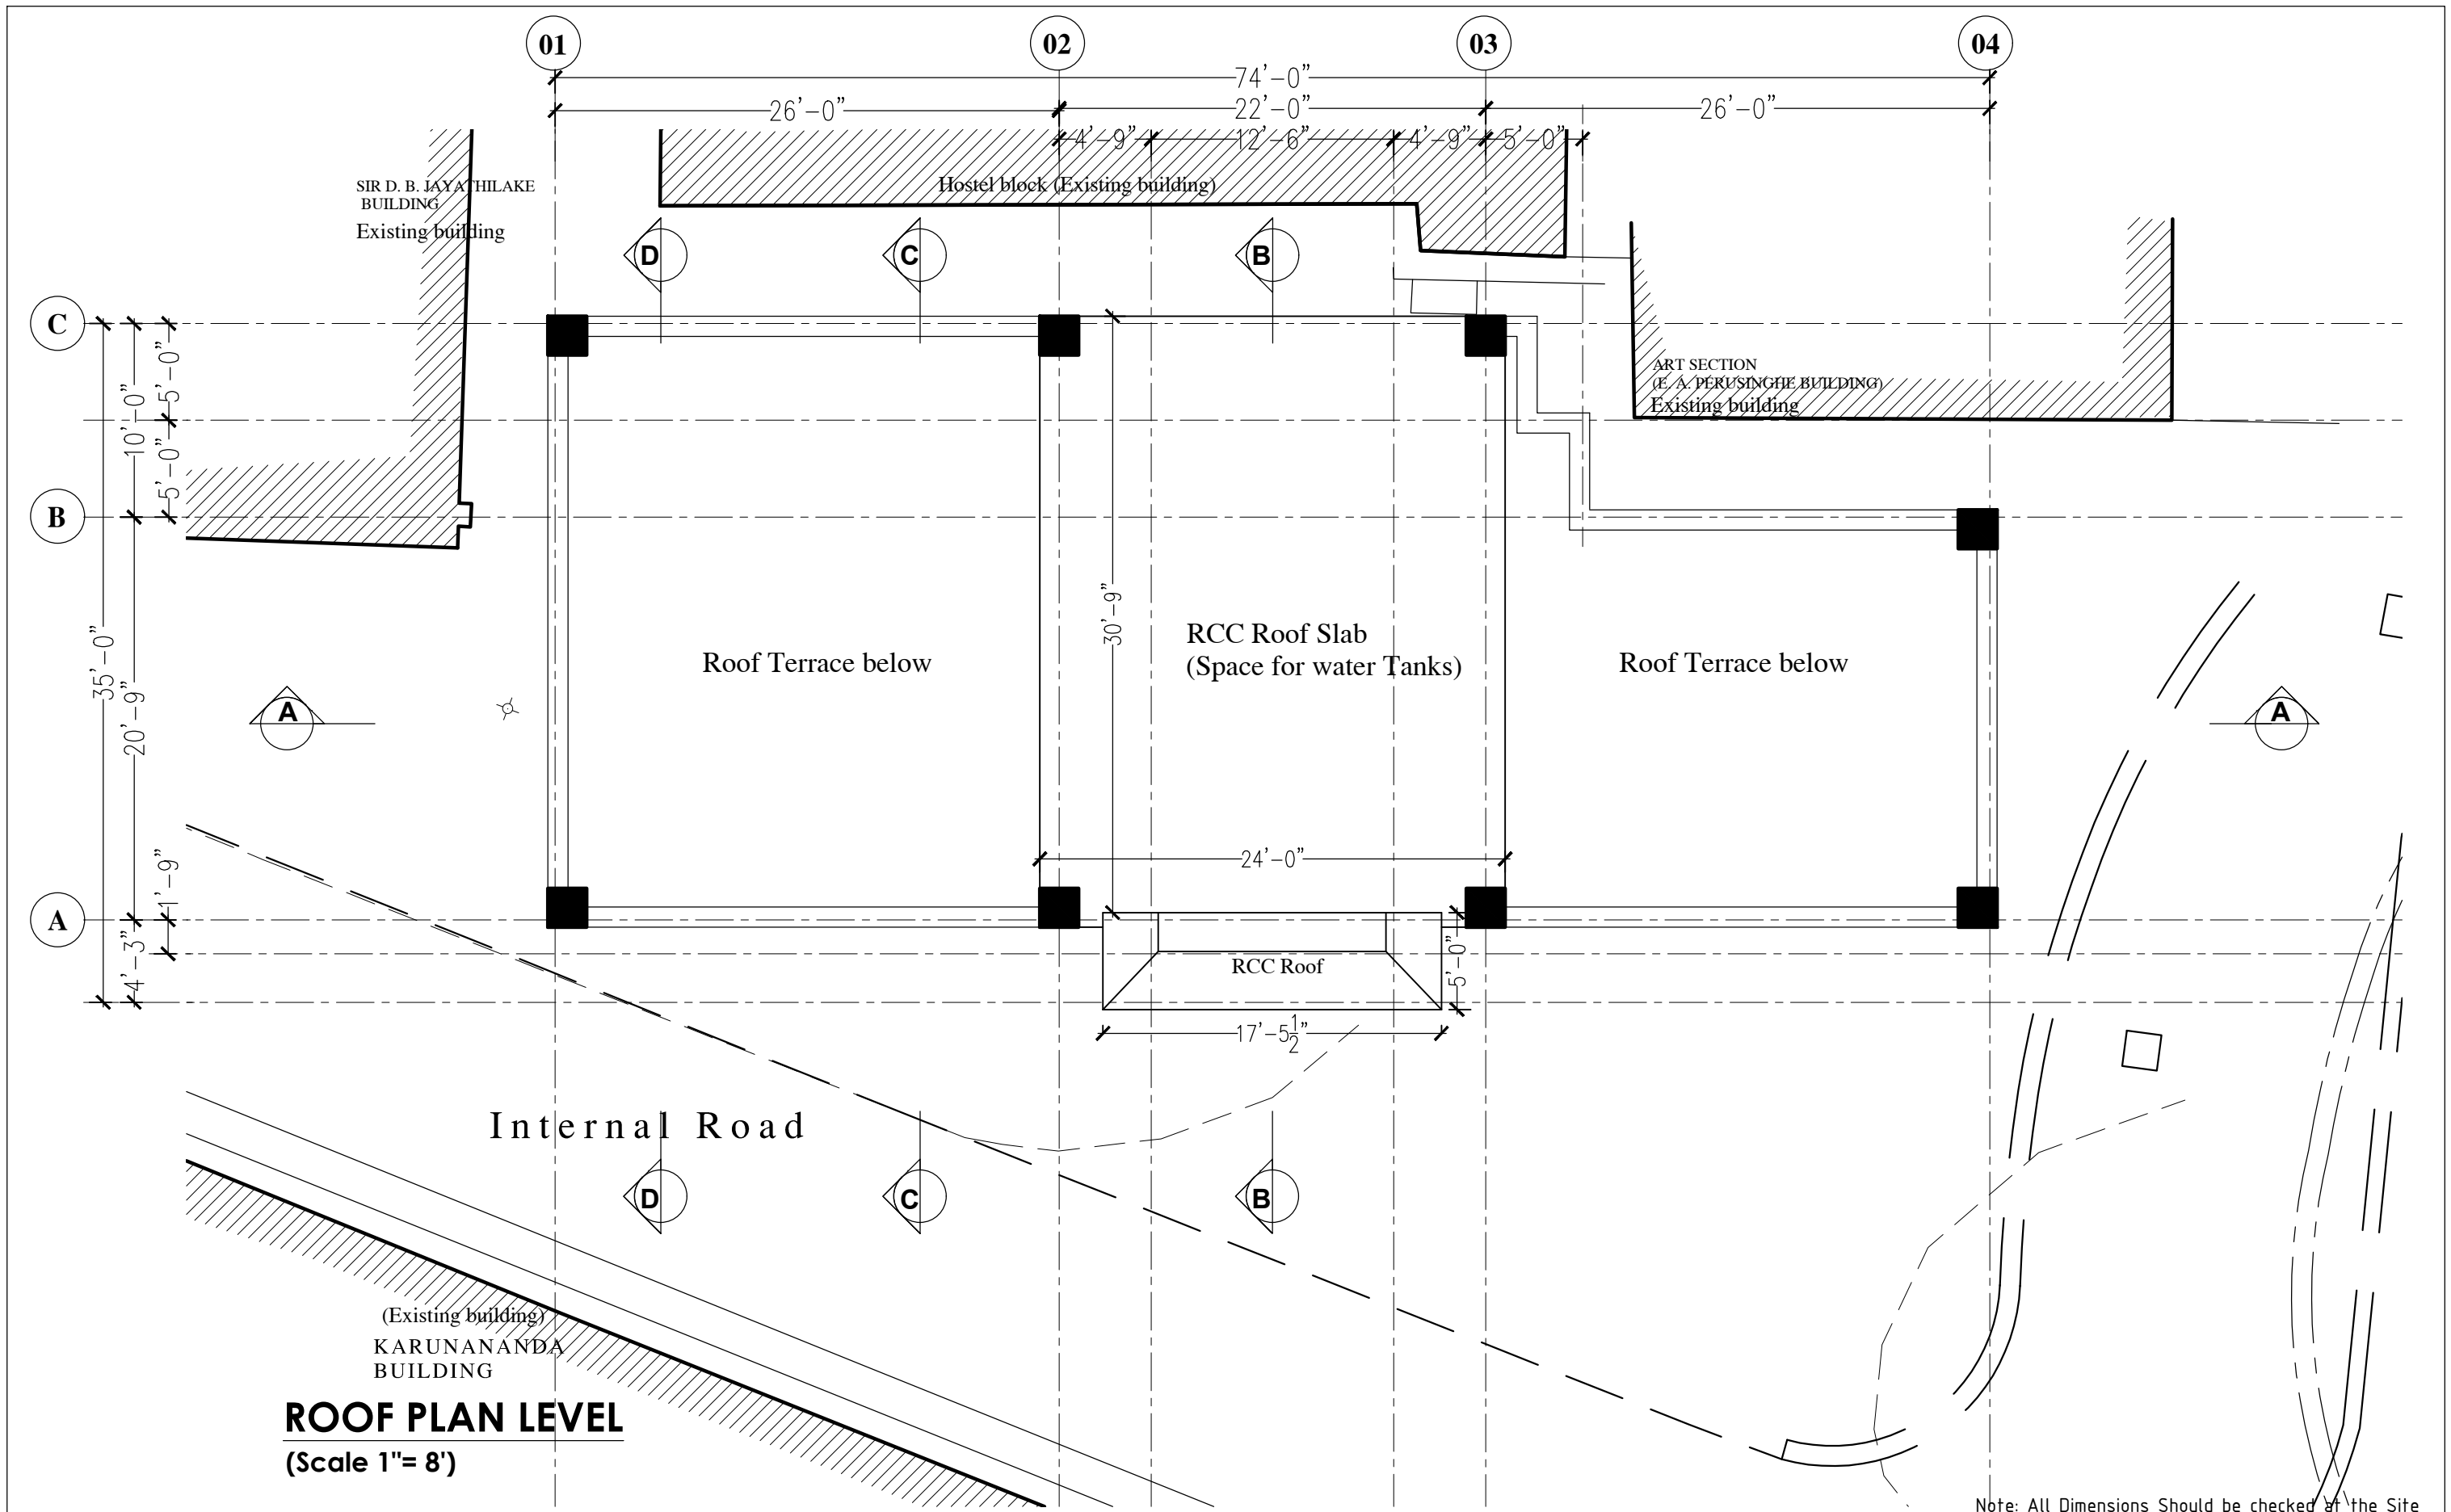

ROOF PLAN LEVEL
(Scale 1"= 8')

Note: All Dimensions Should be checked at the Site

PROJECT :
PROPOSED RESEARCH CENTRE FOR
Ananda Planet Green Force

At Ananda College
Colombo 10.

DRAWING TYPE :
CONSTRUCTION DRAWINGS

ROOF TERRACE-(Ananda Planet Green Force)

CONSULTANT ARCHITECT :
MUDITHA JAYAKODY ASSOCIATES (PVT.) LTD;
CHARTERED ARCHITECTS & CONSORTIUM CONSULTANTS.


NO.212, MAIN HOSPITAL ROAD,
KIRIBATHGODA.

PHONE : (0094)12910787 / FAX NO : (0094)12908294
E-mail : arc.mudithaa@gmail.com

CONSULTANT ENGINEER :

REV.	DATE.	DESCRIPTION	DRAWING NUMBER.
			MJA/And/A05
			SCALE : DATE : 28.05.2024
			SHEET NO. 05
			NTS

D:\Ananada college\GnF Planet_Print\05-Print-PlnGnF-RF_A3.dwg

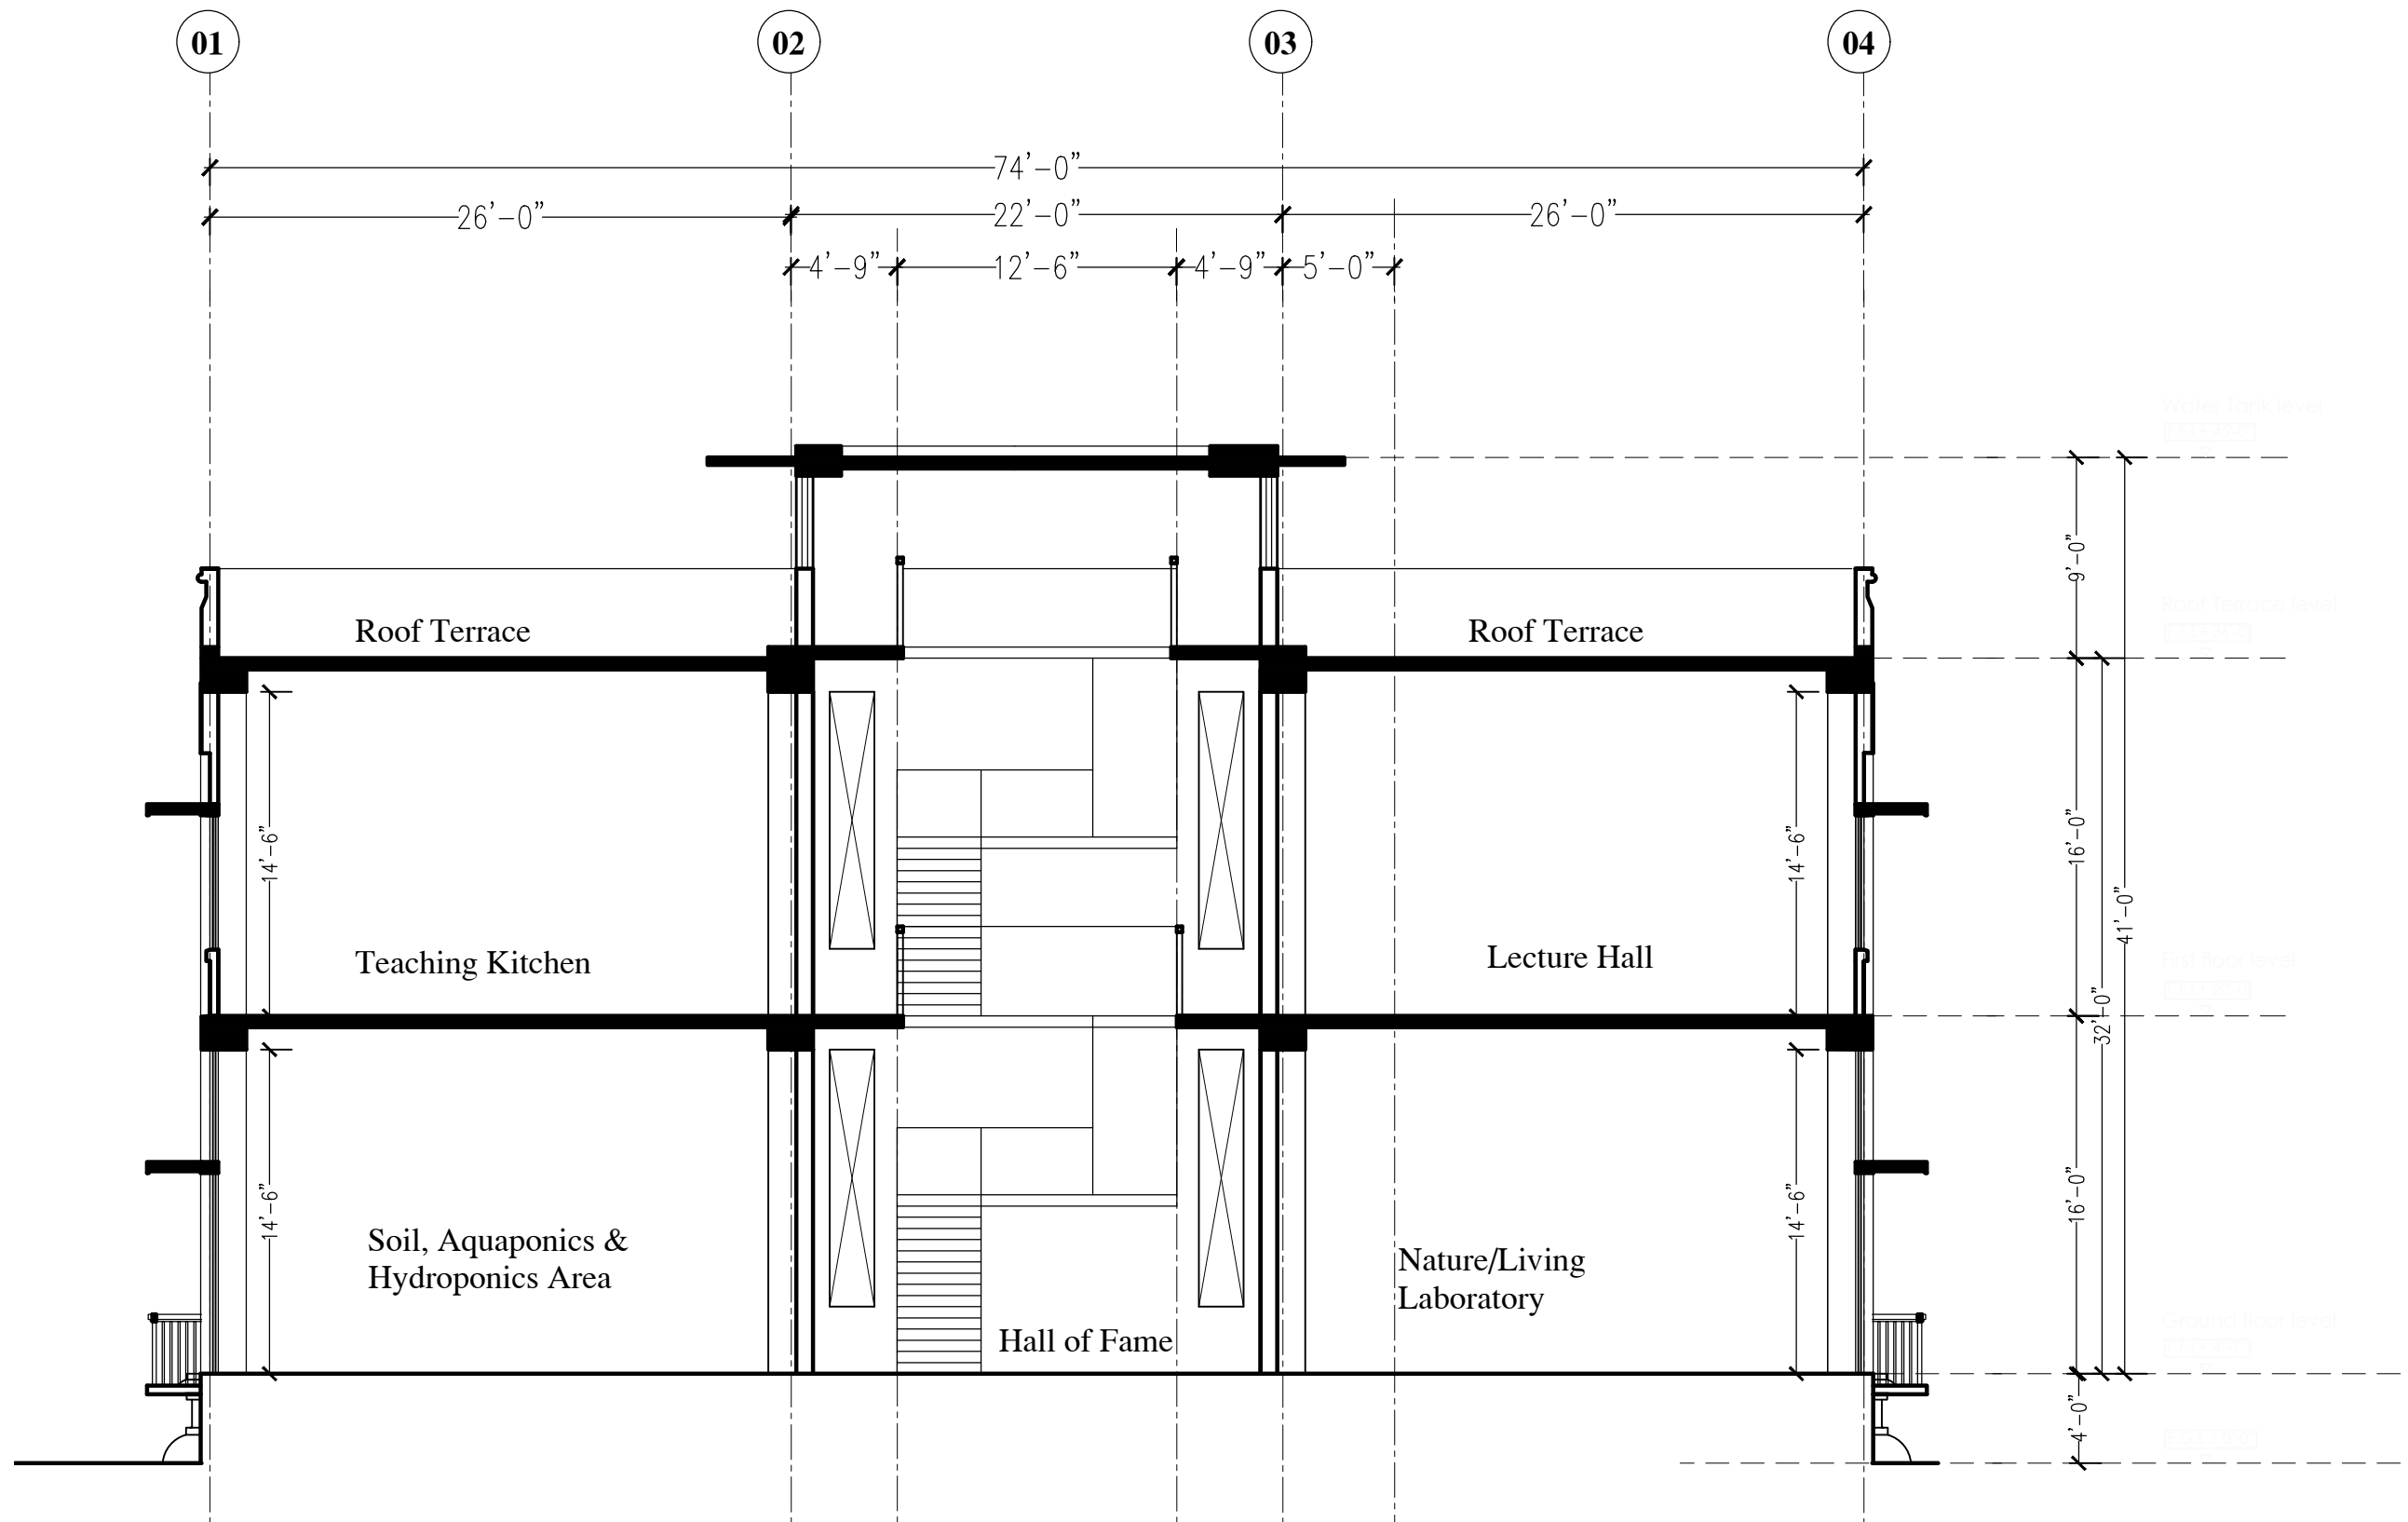

Note: All Dimensions Should be checked at the Site

PROJECT :
PROPOSED RESEARCH CENTRE FOR
Ananda Planet Green Force

At Ananda College
Colombo 10.

DRAWING TYPE :
CONSTRUCTION DRAWINGS

SECTION A-A (Ananda Planet Green Force)


CONSULTANT ARCHITECT :
MUDITHA JAYAKODY ASSOCIATES (PVT.) LTD;
CHARTERED ARCHITECTS & CONSORTIUM CONSULTANTS.

NO.212, MAIN HOSPITAL ROAD,
KIRIBATHGODA.
PHONE : (0094)12910787 / FAX NO : (0094)12908294
E-mail : arc.mudithaa@gmail.com

CONSULTANT ENGINEER :

REV.	DATE.	DESCRIPTION	DRAWING NUMBER.
			MJA/And/A06
			SCALE : DATE : 28.05.2024
			SHEET NO. 06
			NTS

D:\Ananada college\GnF Planet_Print\06-Print-PlnGnF-Sec A-A_A3.dwg

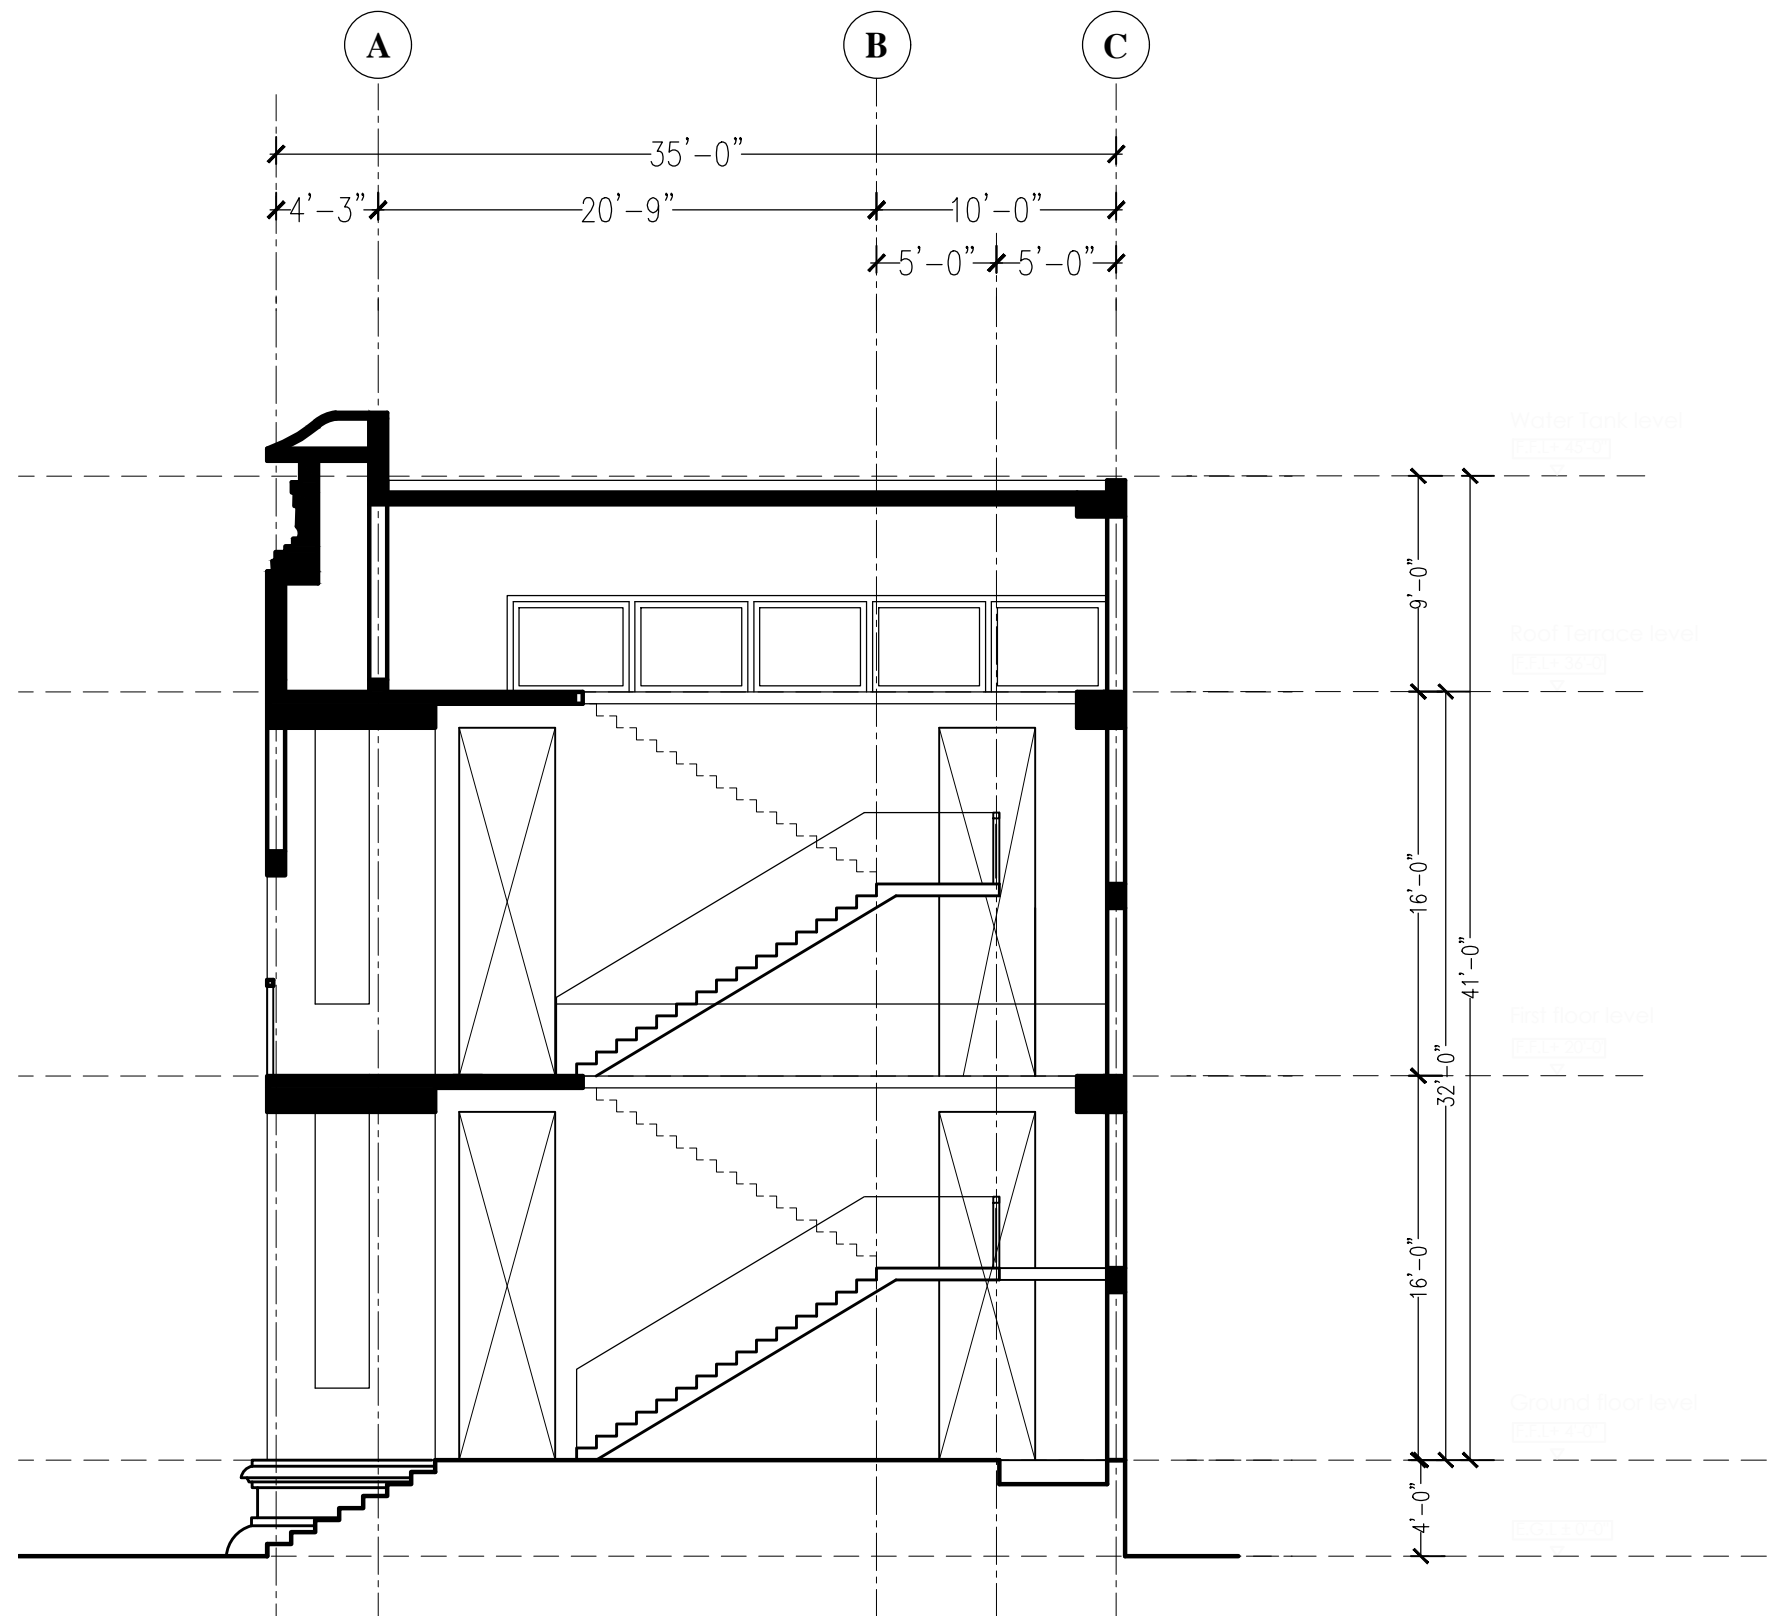

Note: All Dimensions Should be checked at the Site

PROJECT :
PROPOSED RESEARCH CENTRE FOR
Ananda Planet Green Force

At Ananda College
Colombo 10.

DRAWING TYPE :
CONSTRUCTION DRAWINGS

SECTION B-B (Ananda Planet Green Force)

CONSULTANT ARCHITECT :
MUDITHA JAYAKODY ASSOCIATES (PVT.) LTD;
CHARTERED ARCHITECTS & CONSORTIUM CONSULTANTS.


NO.212, MAIN HOSPITAL ROAD,
KIRIBATHGODA.

PHONE : (0094)12910787 / FAX NO : (0094)12908294
E-mail : arc.mudithaa@gmail.com

CONSULTANT ENGINEER :

REV.	DATE.	DESCRIPTION	DRAWING NUMBER.	
			MJA/And/A07	
			SCALE :	DATE : 28.05.2024
			NTS	SHEET NO. 07

D:\Ananada college\GnF Planet_Print\07-Print-PlnGnF-Sec B-B_A3.dwg

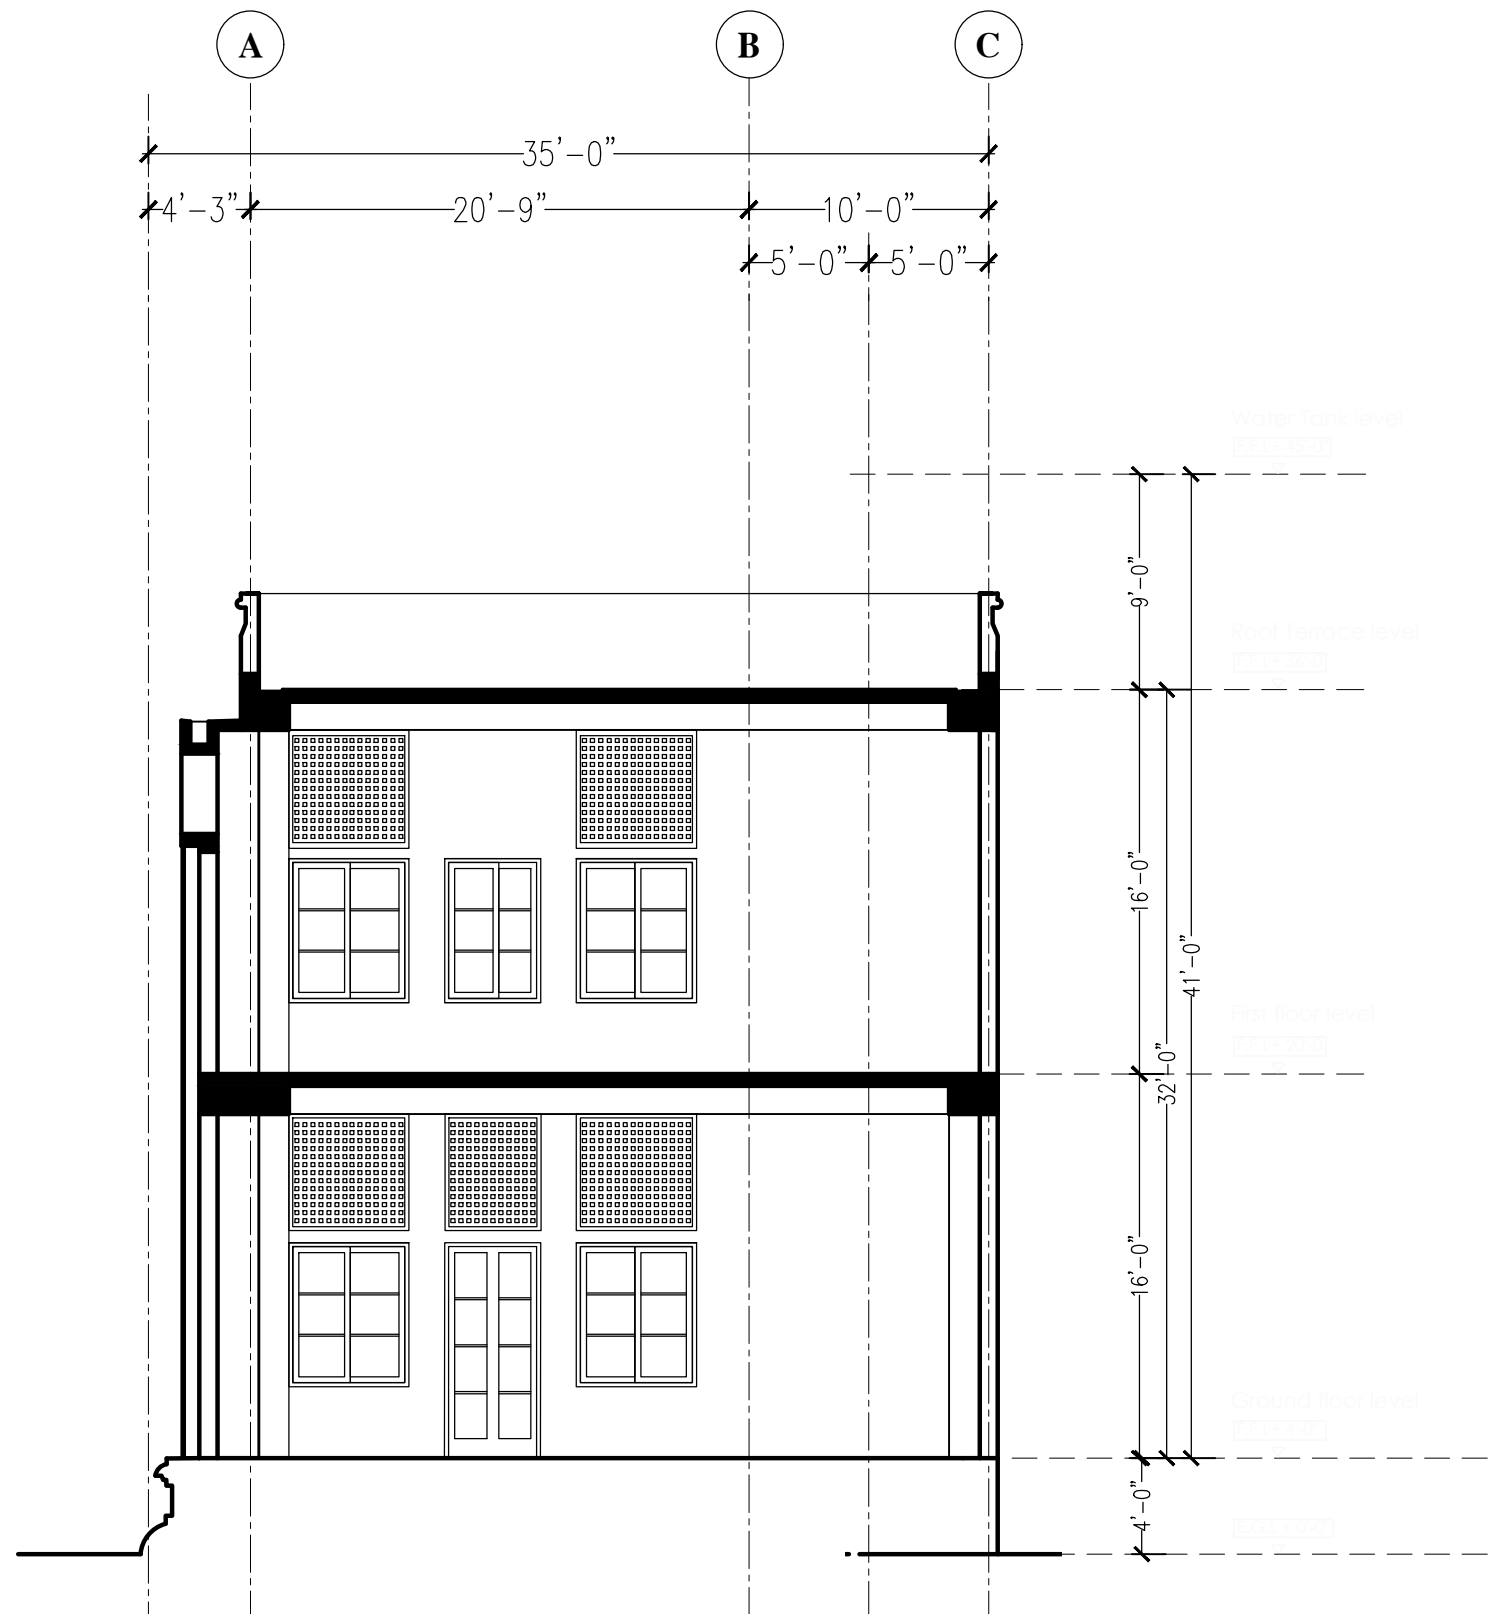

Note: All Dimensions Should be checked at the Site


PROJECT :
 PROPOSED RESEARCH CENTRE FOR
 Ananda Planet Green Force
 At Ananda College
 Colombo 10.

DRAWING TYPE :
 CONSTRUCTION DRAWINGS
 SECTION C-C (Ananda Planet Green Force)

CONSULTANT ARCHITECT :
 MUDITHA JAYAKODY ASSOCIATES (PVT.) LTD;
 CHARTERED ARCHITECTS & CONSORTIUM CONSULTANTS.
 NO.212, MAIN HOSPITAL ROAD,
 KIRIBATHGODA.
 PHONE : (0094)12910787 / FAX NO : (0094)12908294
 E-mail : arc.mudithaa@gmail.com

CONSULTANT ENGINEER :

REV.	DATE.	DESCRIPTION	DRAWING NUMBER.
			MJA/And/A08
			SCALE : DATE : 28.05.2024
			SHEET NO. 08
			NTS

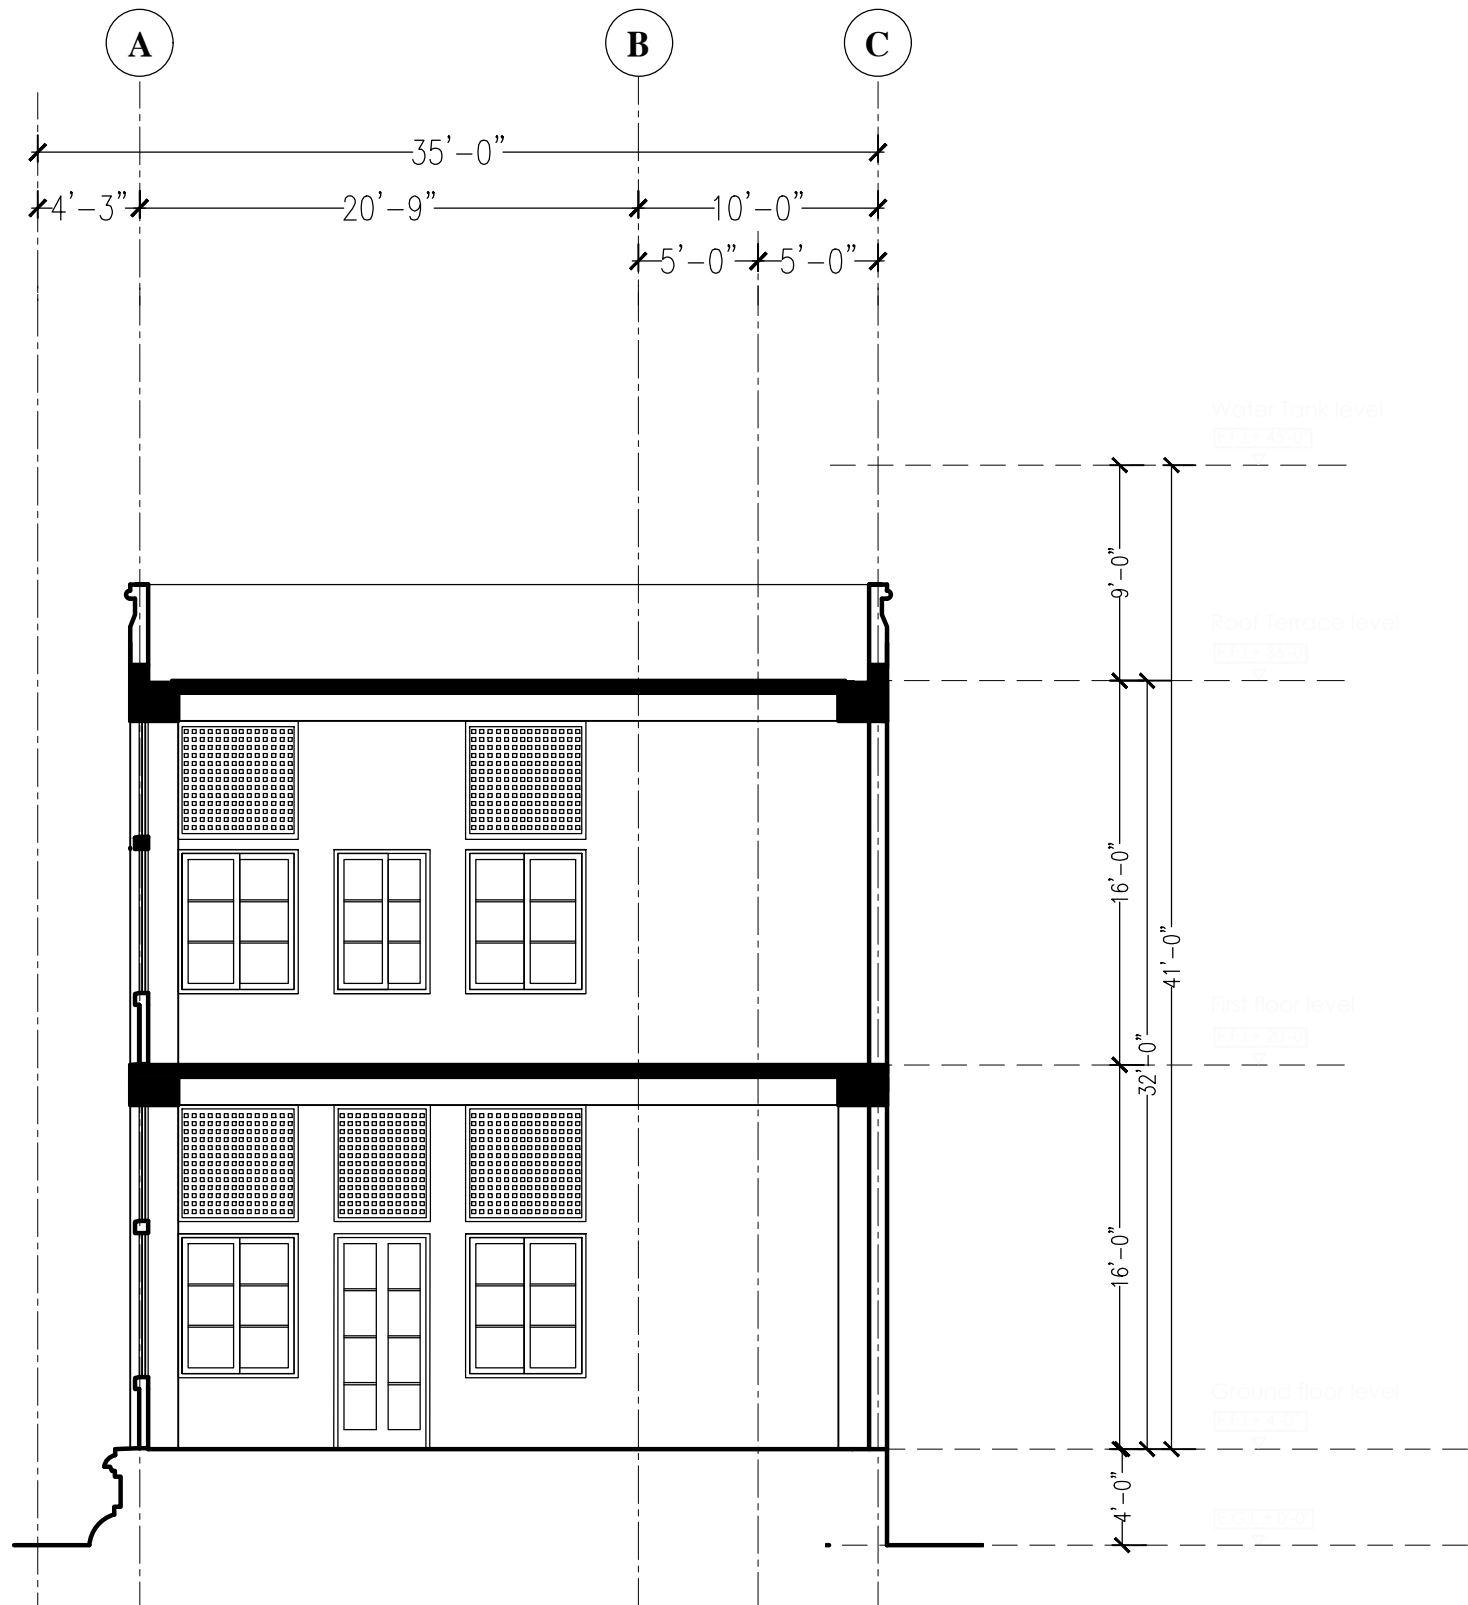

Note: All Dimensions Should be checked at the Site

PROJECT :
 PROPOSED RESEARCH CENTRE FOR
 Ananda Planet Green Force
 At Ananda College
 Colombo 10.


DRAWING TYPE :
 CONSTRUCTION DRAWINGS

SECTION D-D (Ananda Planet Green Force)

CONSULTANT ARCHITECT :
 MUDITHA JAYAKODY ASSOCIATES (PVT.) LTD;
 CHARTERED ARCHITECTS & CONSORTIUM CONSULTANTS.
 NO.212, MAIN HOSPITAL ROAD,
 KIRIBATHGODA.
 PHONE : (0094)12910787 / FAX NO : (0094)12908294
 E-mail : arc.mudithaa@gmail.com

CONSULTANT ENGINEER :

REV.	DATE.	DESCRIPTION	DRAWING NUMBER.
			MJA/And/A09
			SCALE : DATE : 28.05.2024
			SHEET NO. 09
			NTS

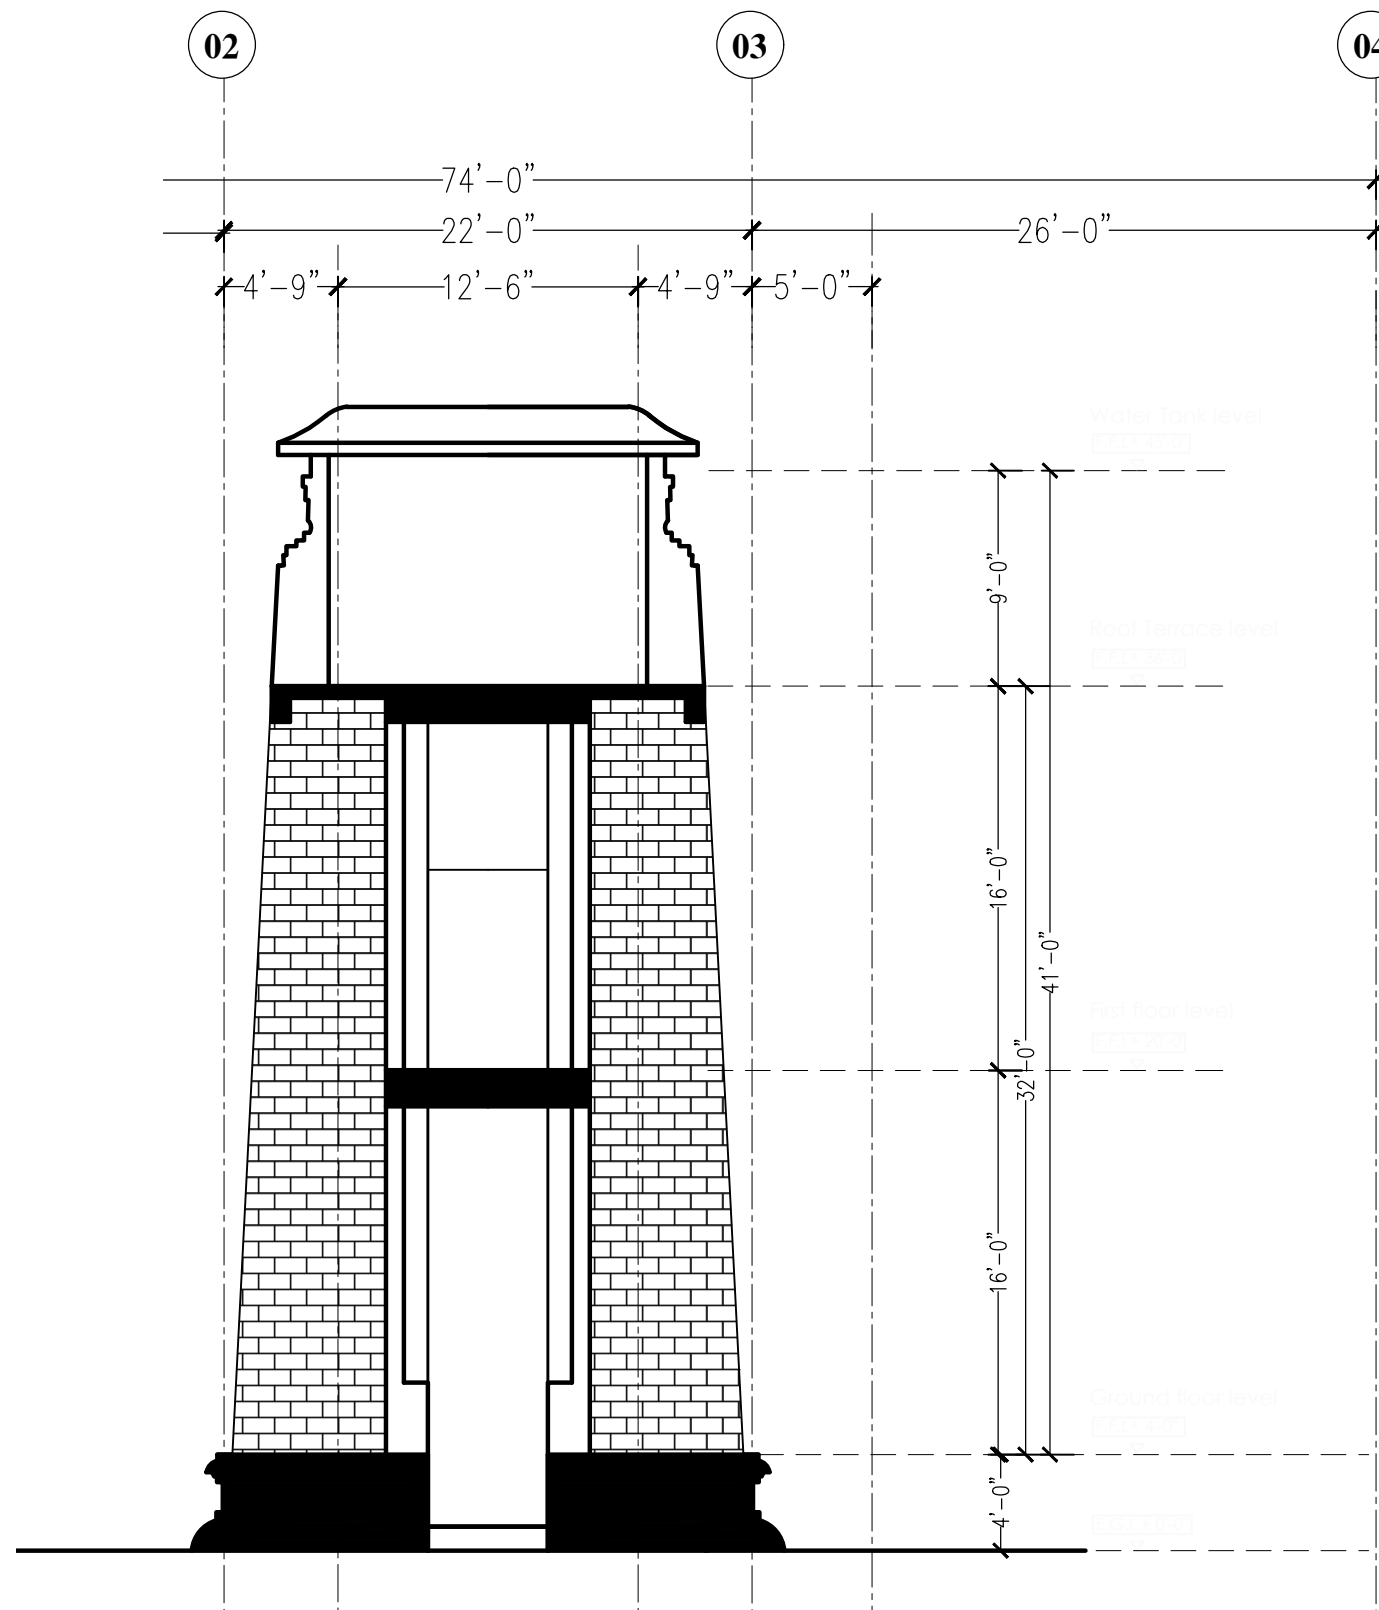

Note: All Dimensions Should be checked at the Site


PROJECT :
 PROPOSED RESEARCH CENTRE FOR
 Ananda Planet Green Force
 At Ananda College
 Colombo 10.

DRAWING TYPE :
 CONSTRUCTION DRAWINGS
SECTION E-E (Ananda Planet Green Force)

CONSULTANT ARCHITECT :
 MUDITHA JAYAKODY ASSOCIATES (PVT.) LTD;
 CHARTERED ARCHITECTS & CONSORTIUM CONSULTANTS.
 NO.212, MAIN HOSPITAL ROAD,
 KIRIBATHGODA.
 PHONE : (0094)12910787 / FAX NO : (0094)12908294
 E-mail : arc.mudithaa@gmail.com

CONSULTANT ENGINEER :

REV.	DATE.	DESCRIPTION	DRAWING NUMBER:	
			MJA/And/A10	
			SCALE :	DATE : 28.05.2024
			NTS	SHEET NO. 10
D:\Ananada college\GnF Planet_Print\10-Print-PlnGnF-Sec E-E_A3.dwg				

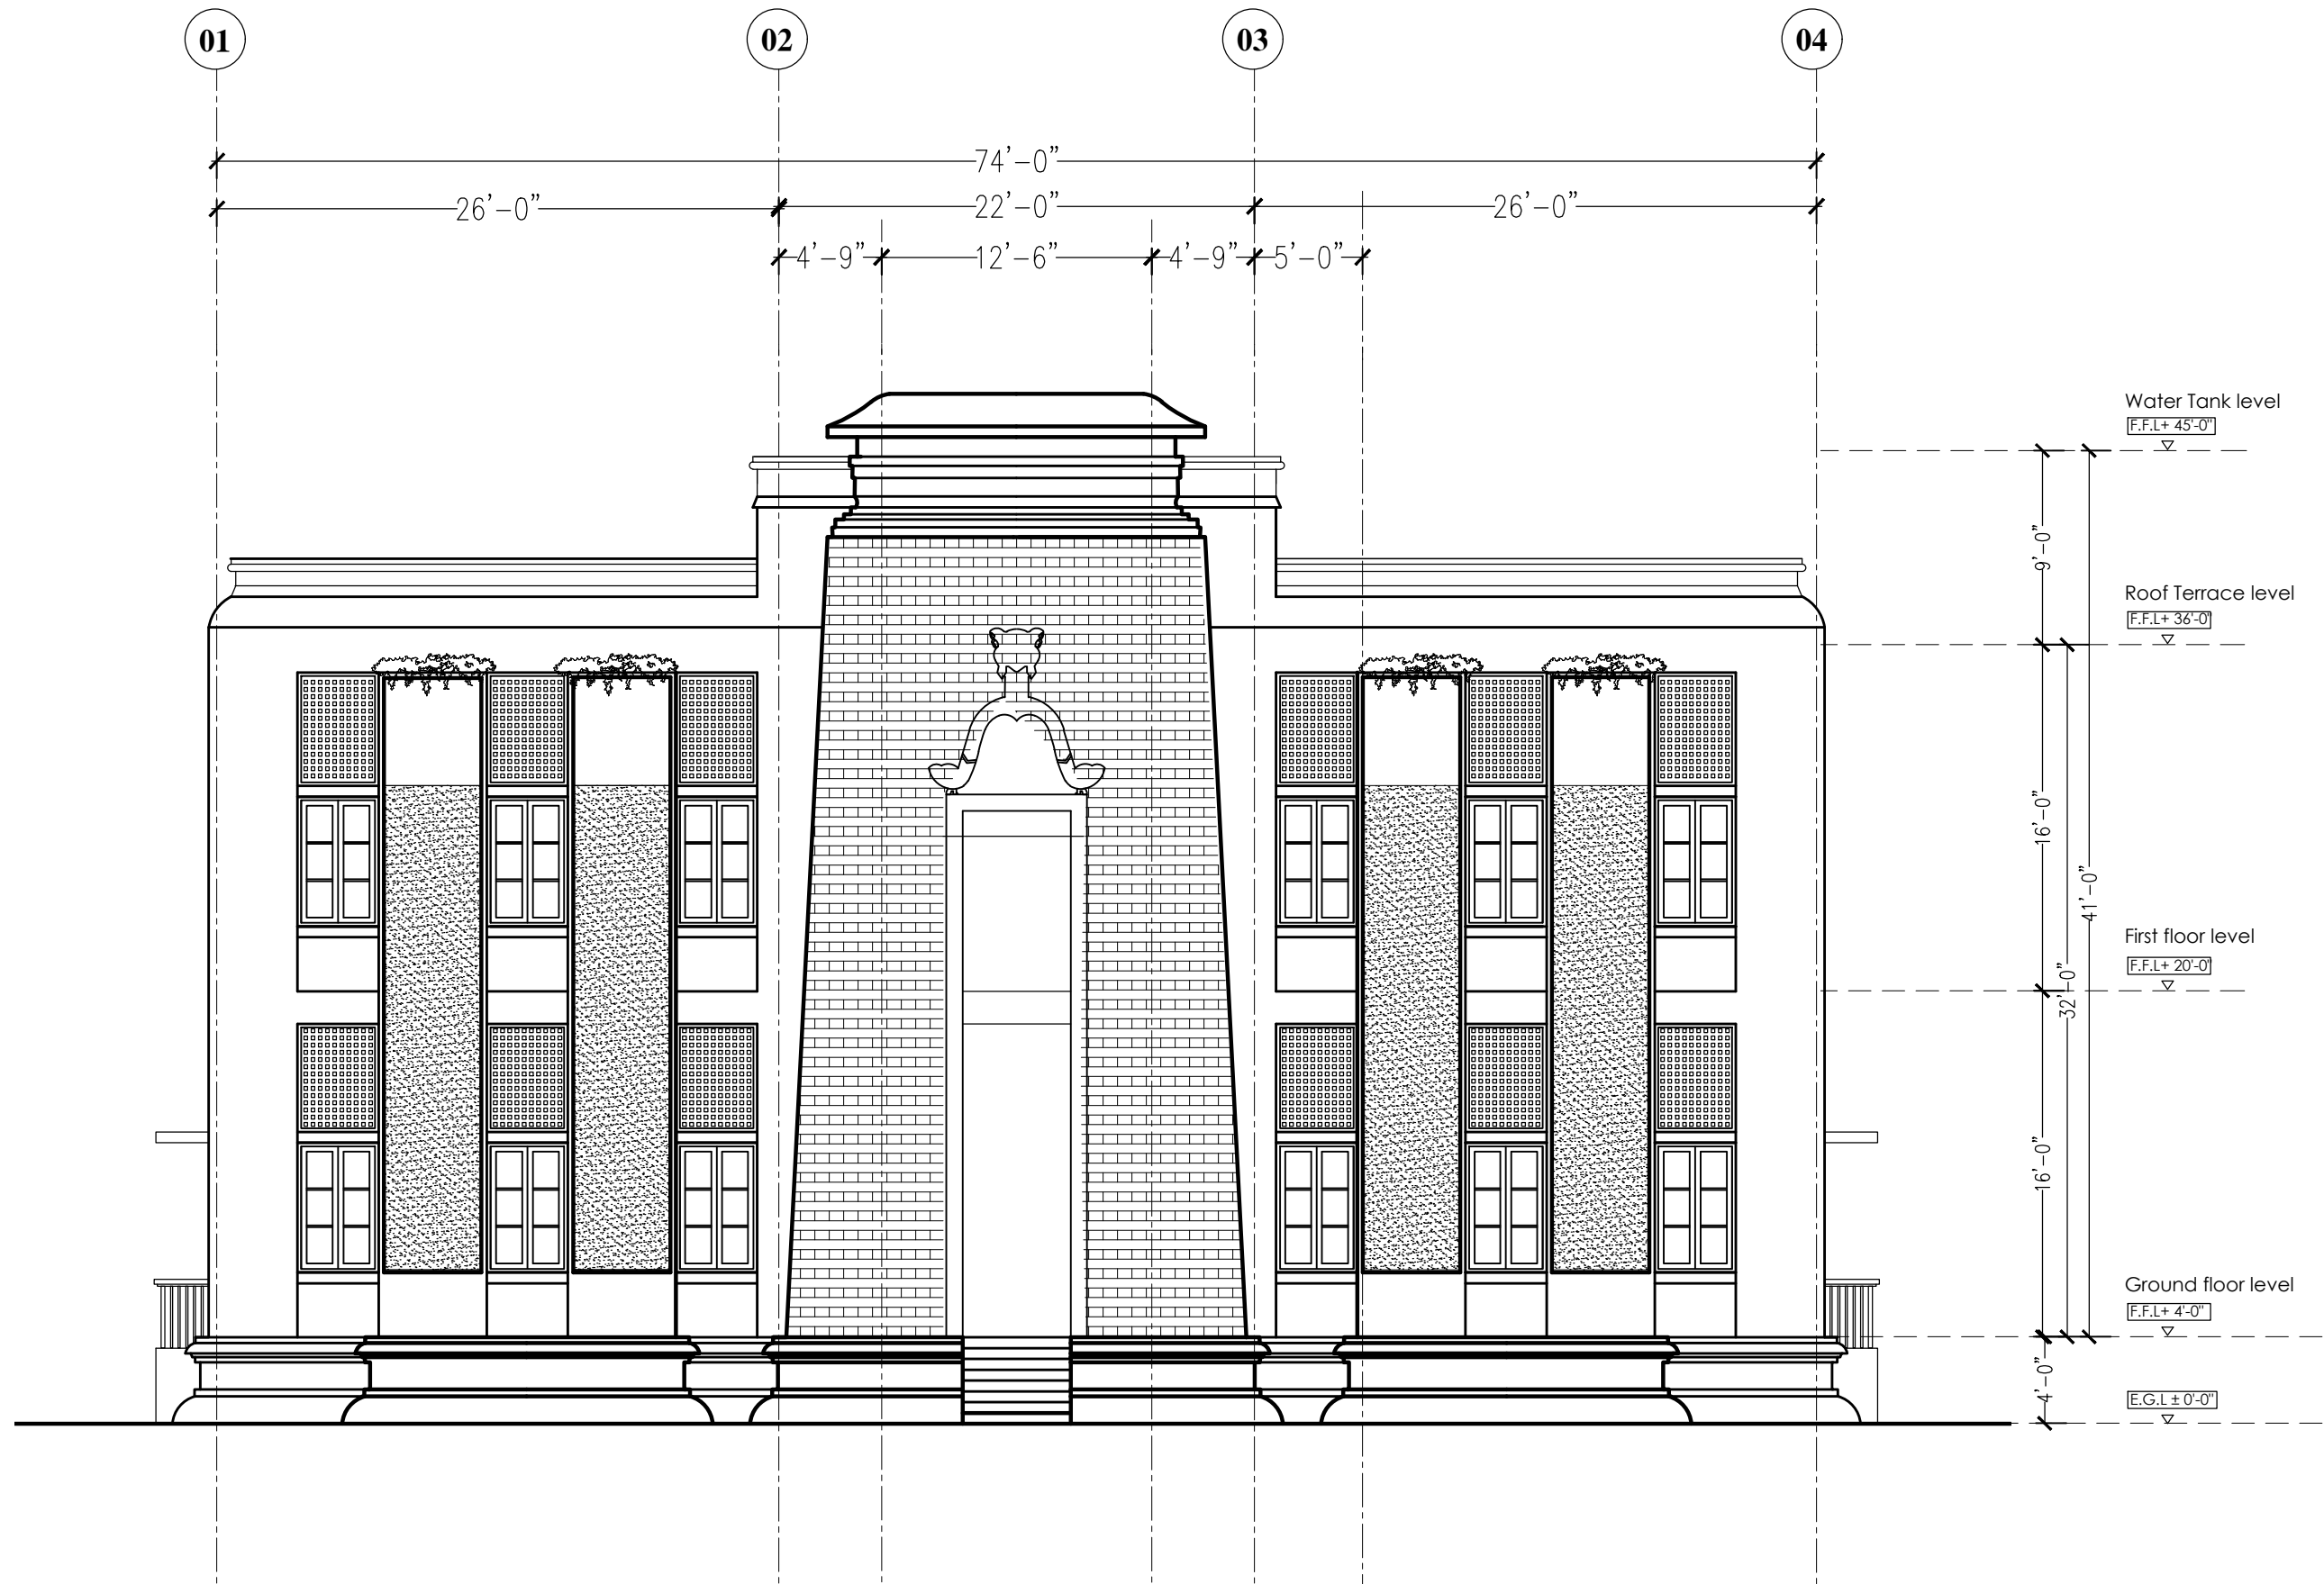

Note: All Dimensions Should be checked at the Site

PROJECT :
 PROPOSED RESEARCH CENTRE FOR
 Ananda Planet Green Force
 At Ananda College
 Colombo 10.


DRAWING TYPE :
 CONSTRUCTION DRAWINGS
 FRONT ELEVATION(Ananda Planet Green Force)

CONSULTANT ARCHITECT :
 MUDITHA JAYAKODY ASSOCIATES (PVT.) LTD;
 CHARTERED ARCHITECTS & CONSORTIUM CONSULTANTS.
 NO.212, MAIN HOSPITAL ROAD,
 KIRIBATHGODA.
 PHONE : (0094)12910787 / FAX NO : (0094)12908294
 E-mail : arc.mudithaa@gmail.com

CONSULTANT ENGINEER :

REV.	DATE.	DESCRIPTION	DRAWING NUMBER.
			MJA/And/A11
			SCALE : DATE : 28.05.2024
			SHEET NO. 11
			NTS

D:\Ananada college\GnF Planet_Print\11-Print-PlnGrF-Front Elev_A3.dwg

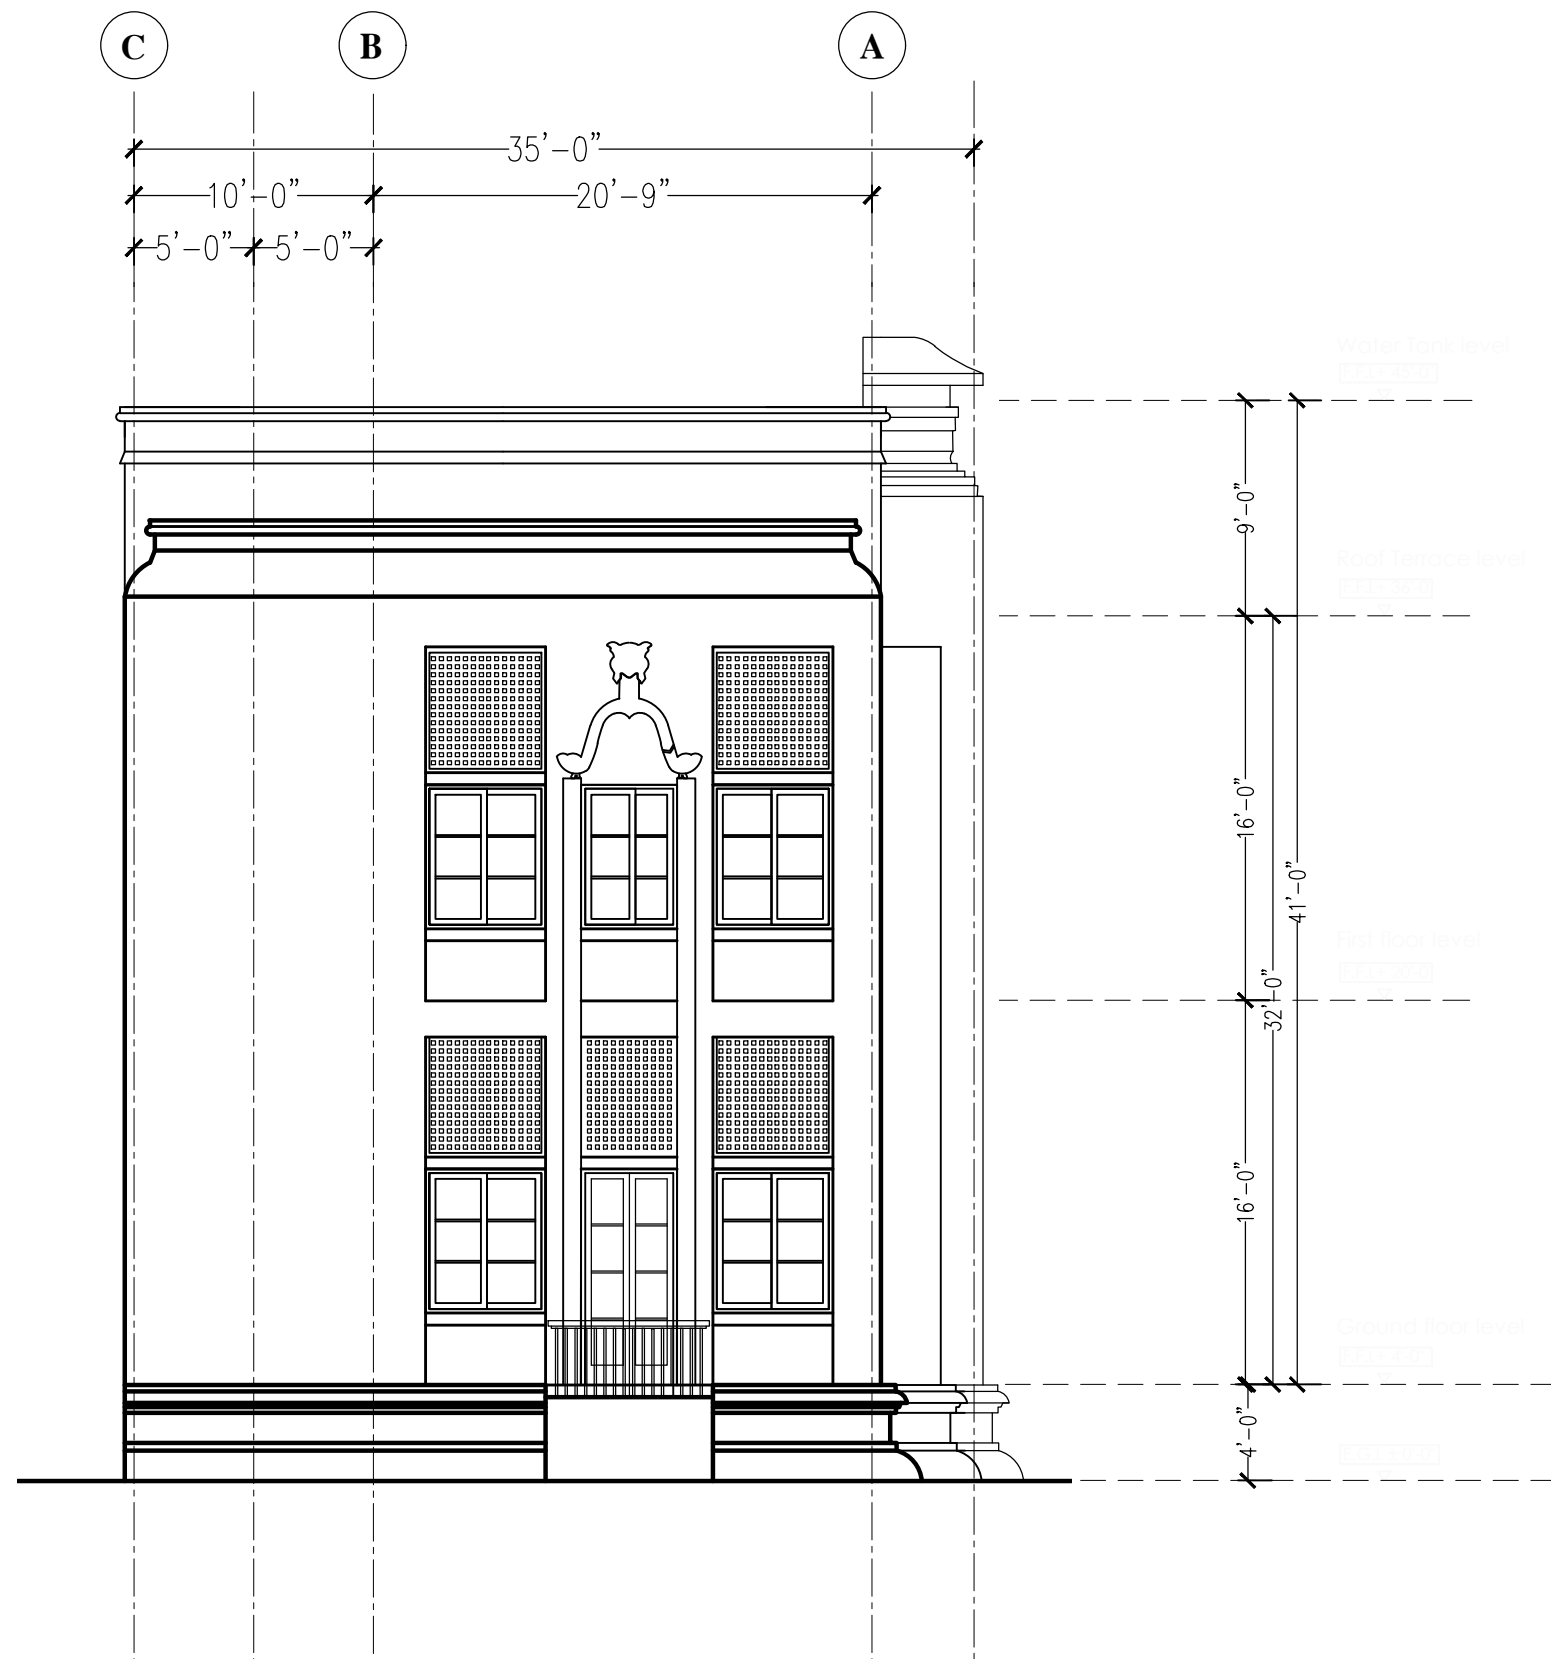

Note: All Dimensions Should be checked at the Site

PROJECT :
 PROPOSED RESEARCH CENTRE FOR
 Ananda Planet Green Force
 At Ananda College
 Colombo 10.

DRAWING TYPE :
 CONSTRUCTION DRAWINGS


SIDE ELEVATION(Ananda Planet Green Force)

CONSULTANT ARCHITECT :
 MUDITHA JAYAKODY ASSOCIATES (PVT.) LTD;
 CHARTERED ARCHITECTS & CONSORTIUM CONSULTANTS.
 NO.212, MAIN HOSPITAL ROAD,
 KIRIBATHGODA.
 PHONE : (0094)12910787 / FAX NO : (0094)12908294
 E-mail : arc.mudithaa@gmail.com

CONSULTANT ENGINEER :

REV.	DATE.	DESCRIPTION	DRAWING NUMBER:	
			MJA/And/A12	
			SCALE :	DATE : 28.05.2024
			NTS	SHEET NO. 12

D:\Ananada college\GnF Planet_Print\12-Print-PlnGnF-Side Elevation_A3.dwg

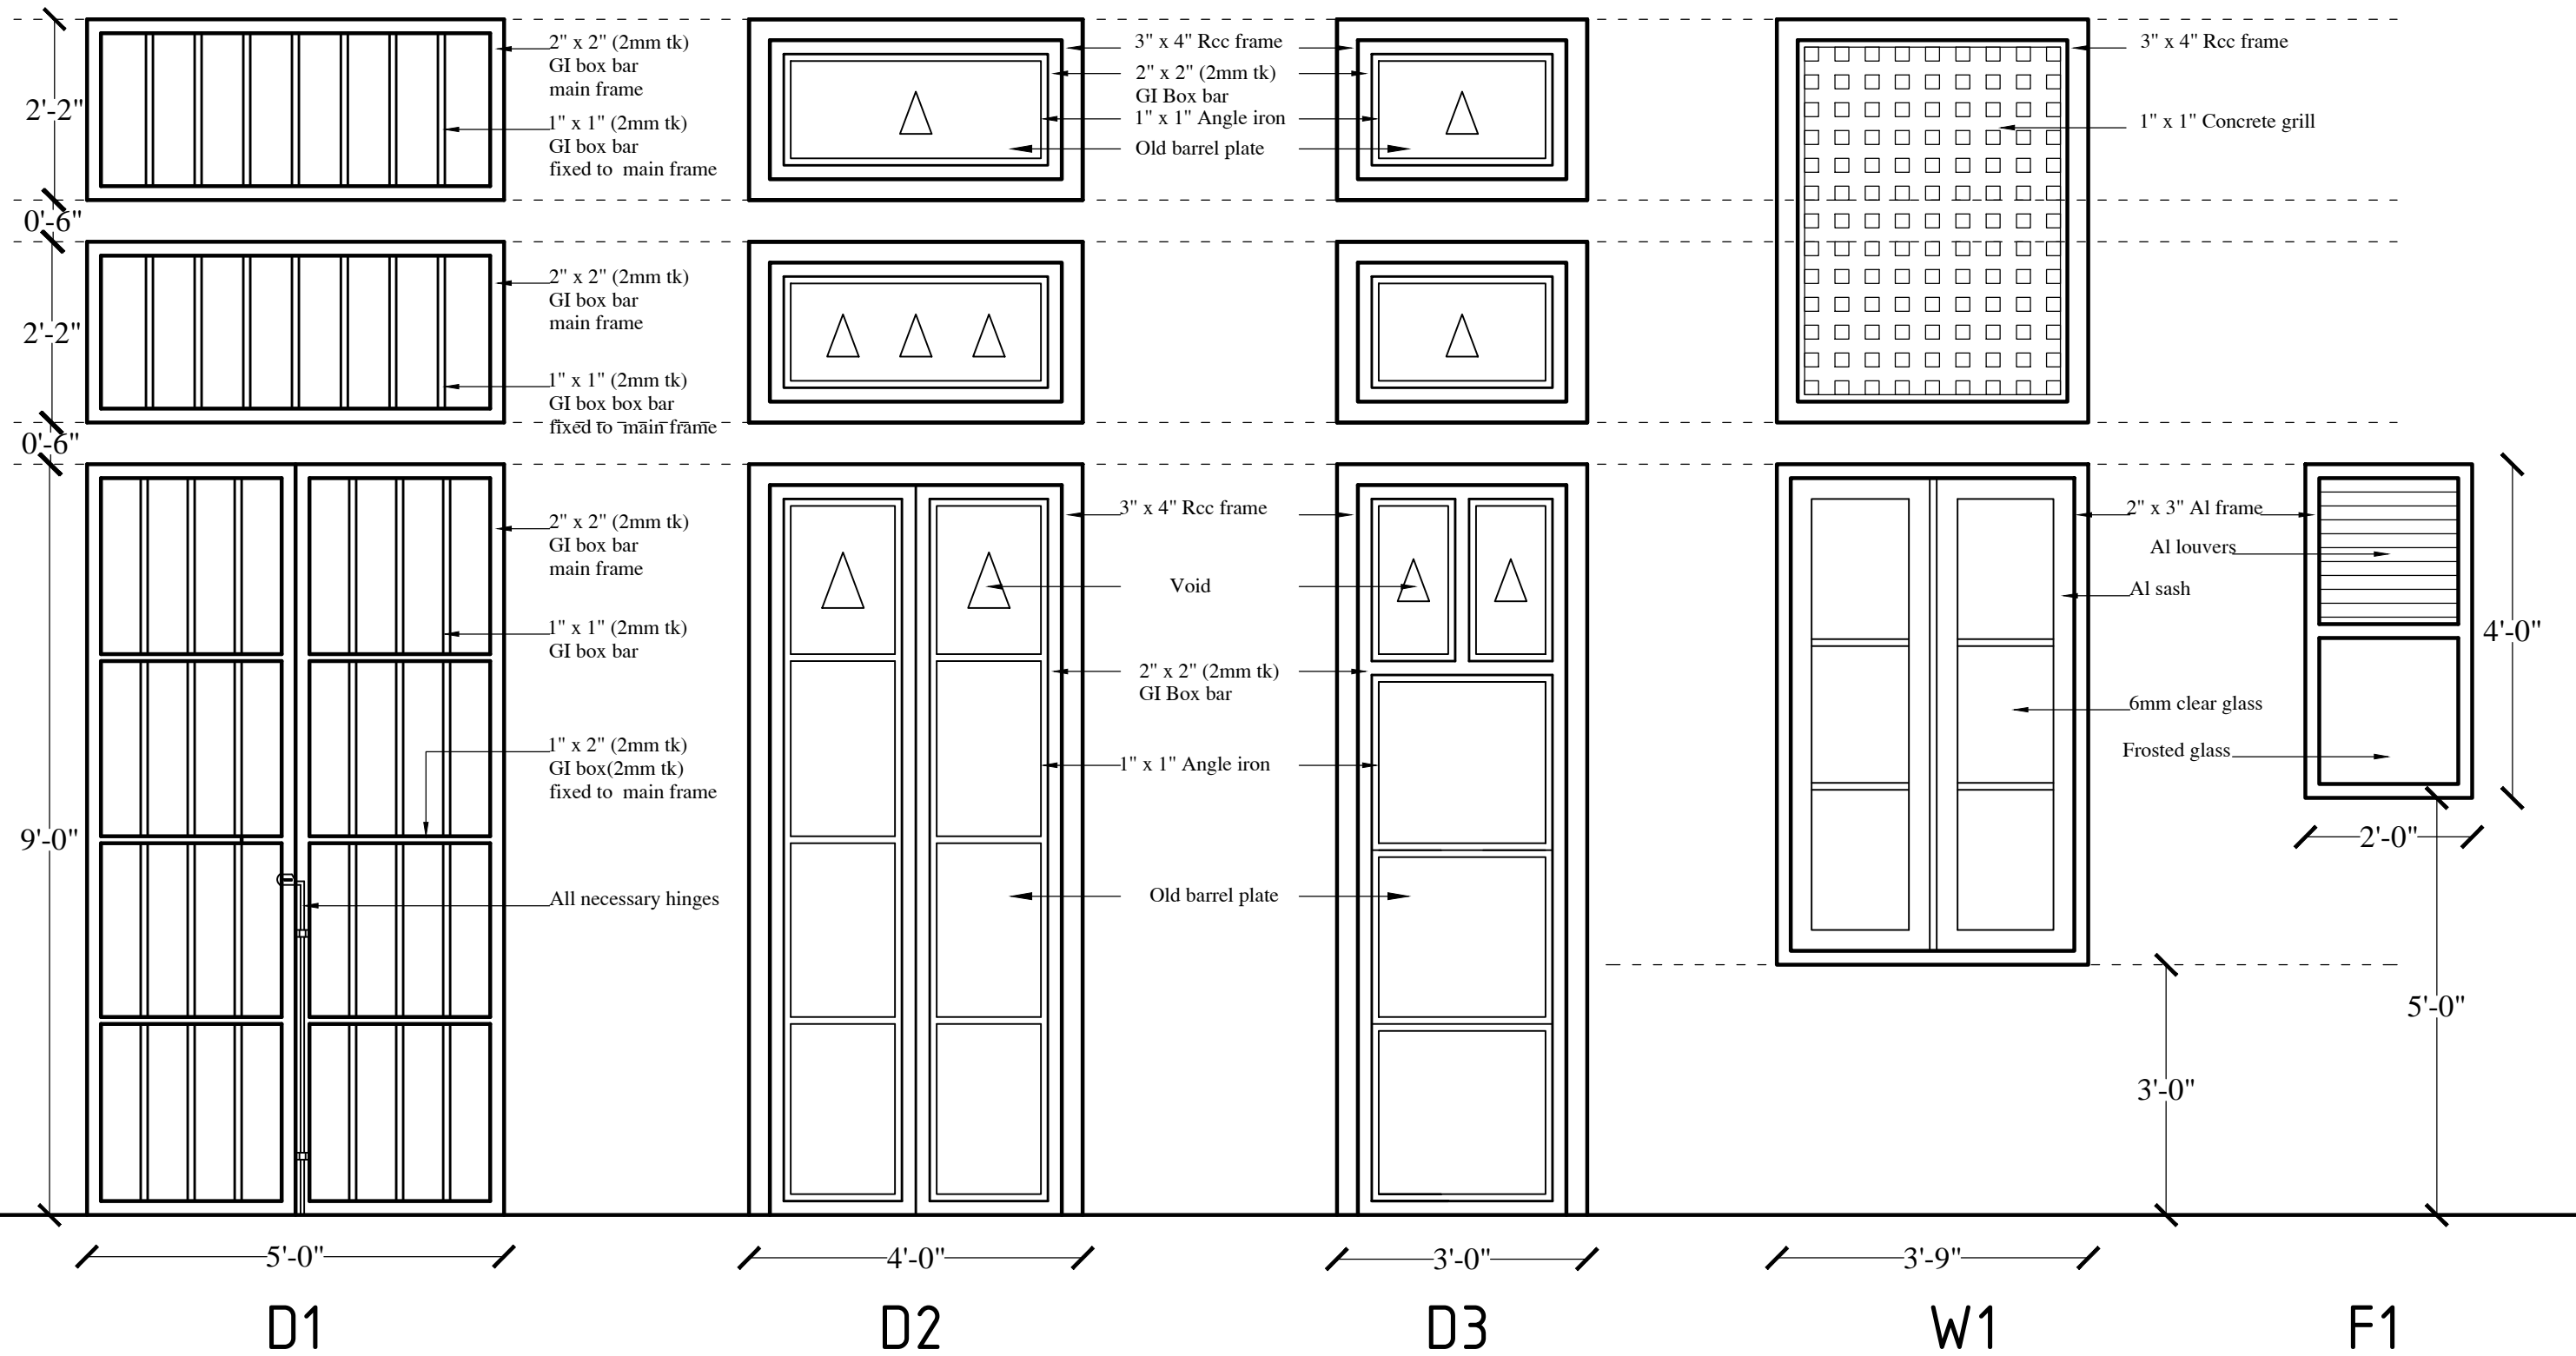

Note: All Dimensions Should be checked at the Site

PROJECT :
 PROPOSED RESEARCH CENTRE FOR
 Ananda Planet Green Force
 At Ananda College
 Colombo 10.


DRAWING TYPE :
 CONSTRUCTION DRAWINGS
 Detail of Doors/windos
 (Ananda Planet Green Force)

CONSULTANT ARCHITECT :
 MUDITHA JAYAKODY ASSOCIATES (PVT.) LTD;
 CHARTERED ARCHITECTS & CONSORTIUM CONSULTANTS.
 NO.212, MAIN HOSPITAL ROAD,
 KIRIBATHGODA.
 PHONE : (0094)12910787 / FAX NO : (0094)12908294
 E-mail : arc.mudithaa@gmail.com

CONSULTANT ENGINEER :


REV.	DATE.	DESCRIPTION	DRAWING NUMBER.
			MJA/And/A13
			SCALE : DATE : 28.05.2024
			SHEET NO. 13
			NTS

D:\Ananada college\GnF Planet_Print\13-Print-PlnGnF-Det-DW_A3.dwg

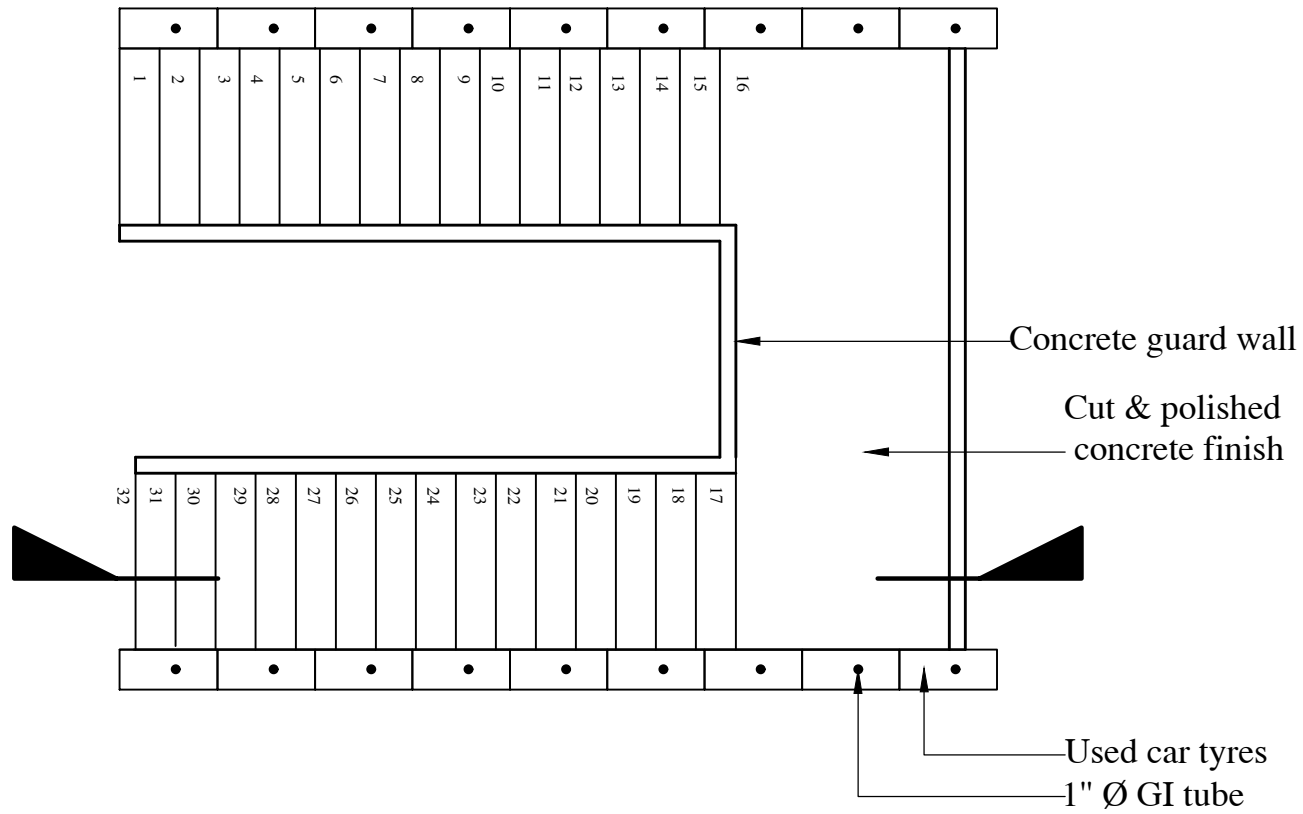

TYPICAL PLAN

RISER = 0'6"
 TREAD = 0'10"
 STEPS = 32
 FF HEIGHT = 16'0"

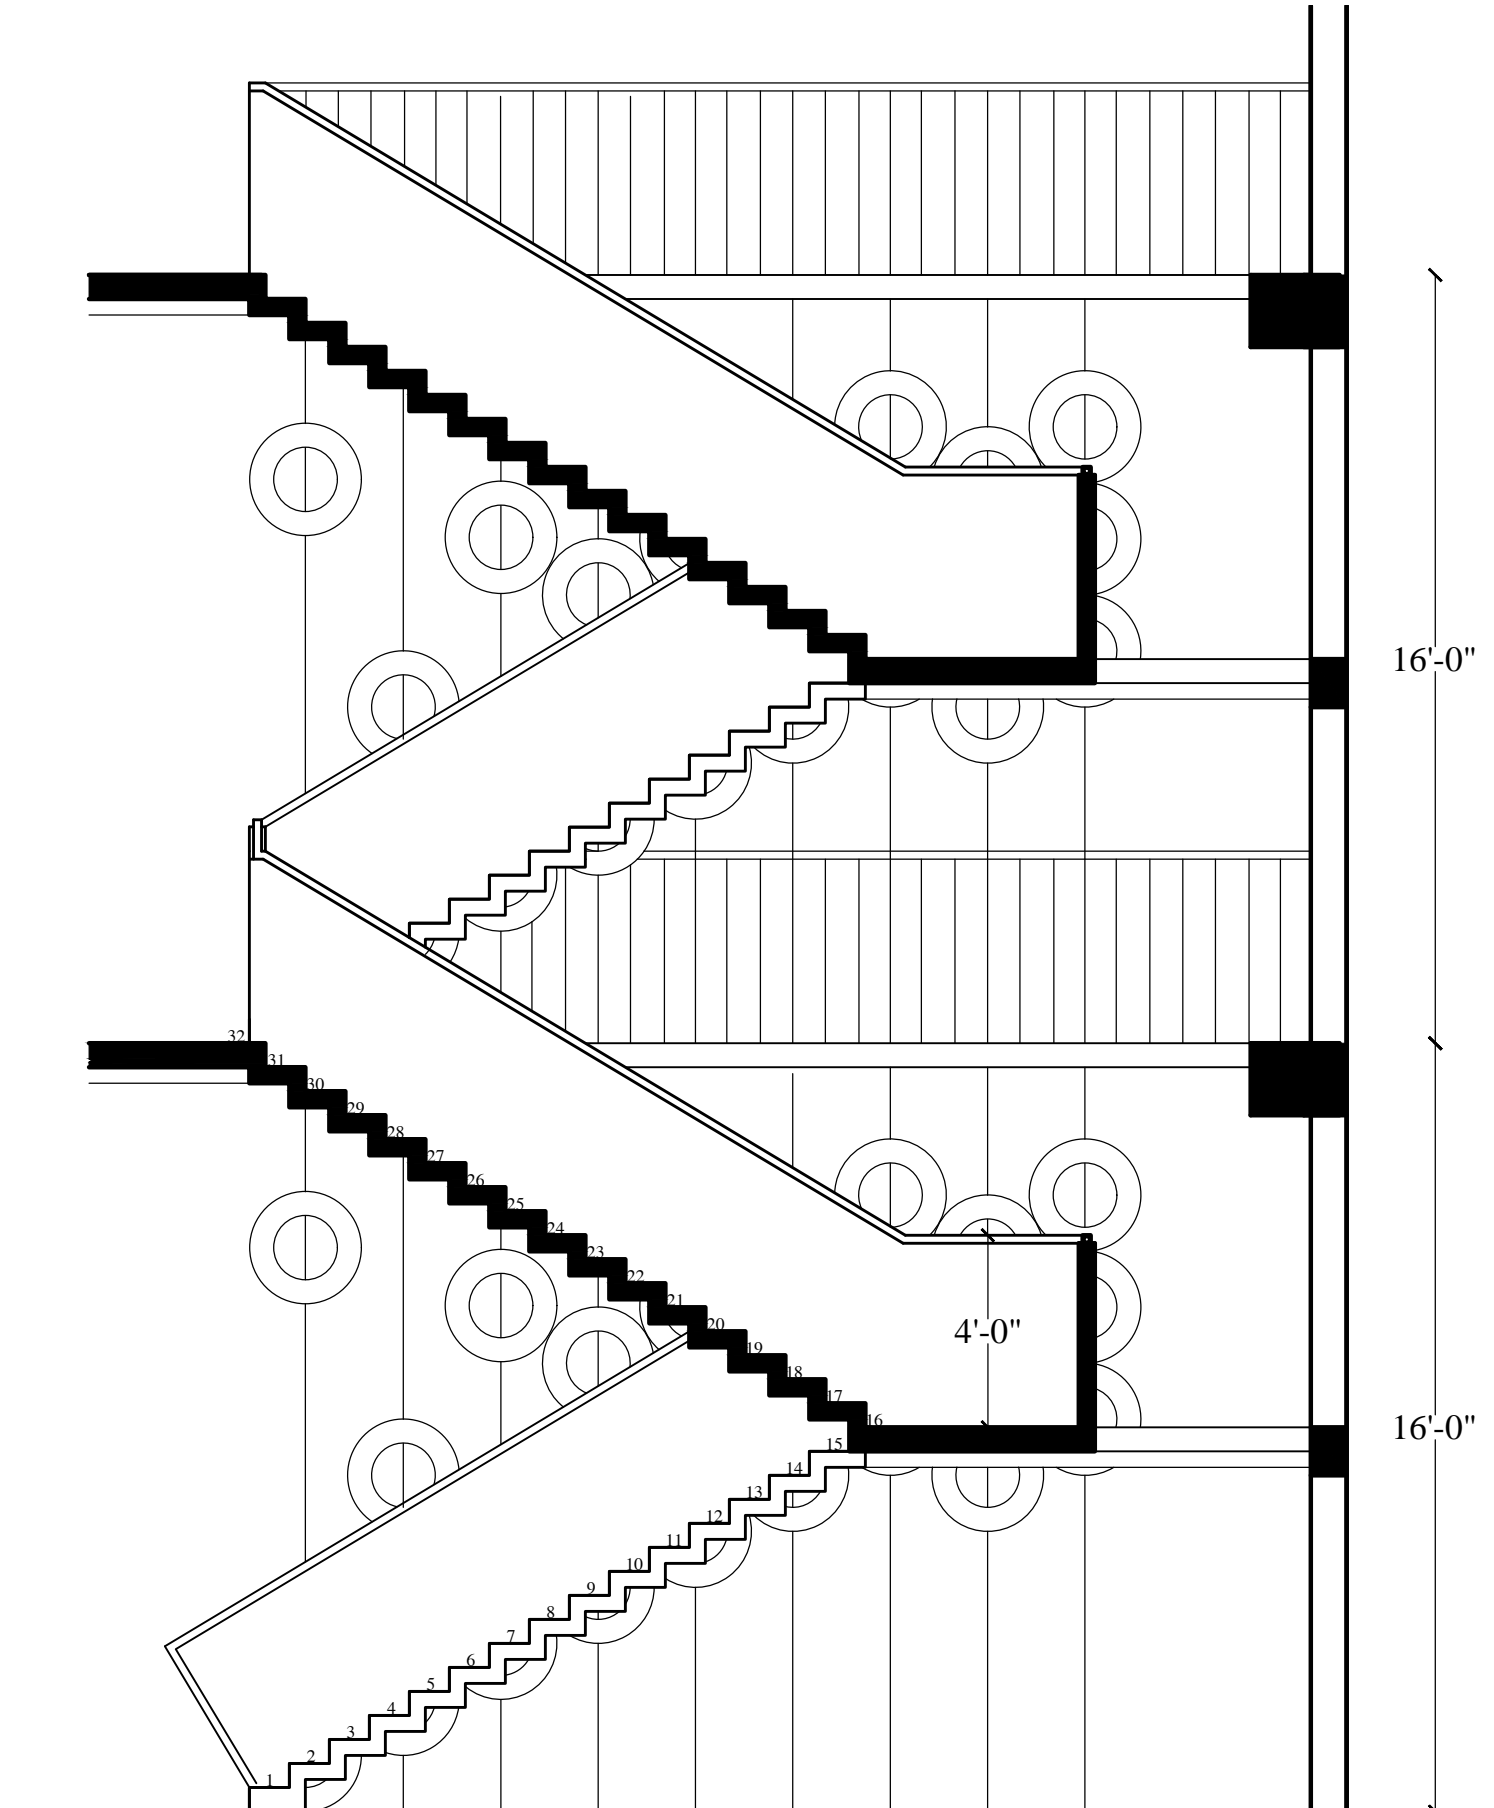

Note: All Dimensions Should be checked at the Site

PROJECT :
 PROPOSED RESEARCH CENTRE FOR
 Ananda Planet Green Force

 At Ananda College
 Colombo 10.


DRAWING TYPE :
 CONSTRUCTION DRAWINGS
 Detail of staircase
 (Ananda Planet Green Force)

CONSULTANT ARCHITECT :
 MUDITHA JAYAKODY ASSOCIATES (PVT.) LTD;
 CHARTERED ARCHITECTS & CONSORTIUM CONSULTANTS.
 NO.212, MAIN HOSPITAL ROAD,
 KIRIBATHGODA.
 PHONE : (0094)12910787 / FAX NO : (0094)12908294
 E-mail : arc.mudithaa@gmail.com

CONSULTANT ENGINEER :

REV.	DATE.	DESCRIPTION	DRAWING NUMBER.
			MJA/And/A14
			SCALE : DATE : 28.05.2024
			SHEET NO. 14
			NTS

D:\Ananada college\GnF Planet_Print\14-Print-PlnGnF-Det-staircase-01_A3.dwg

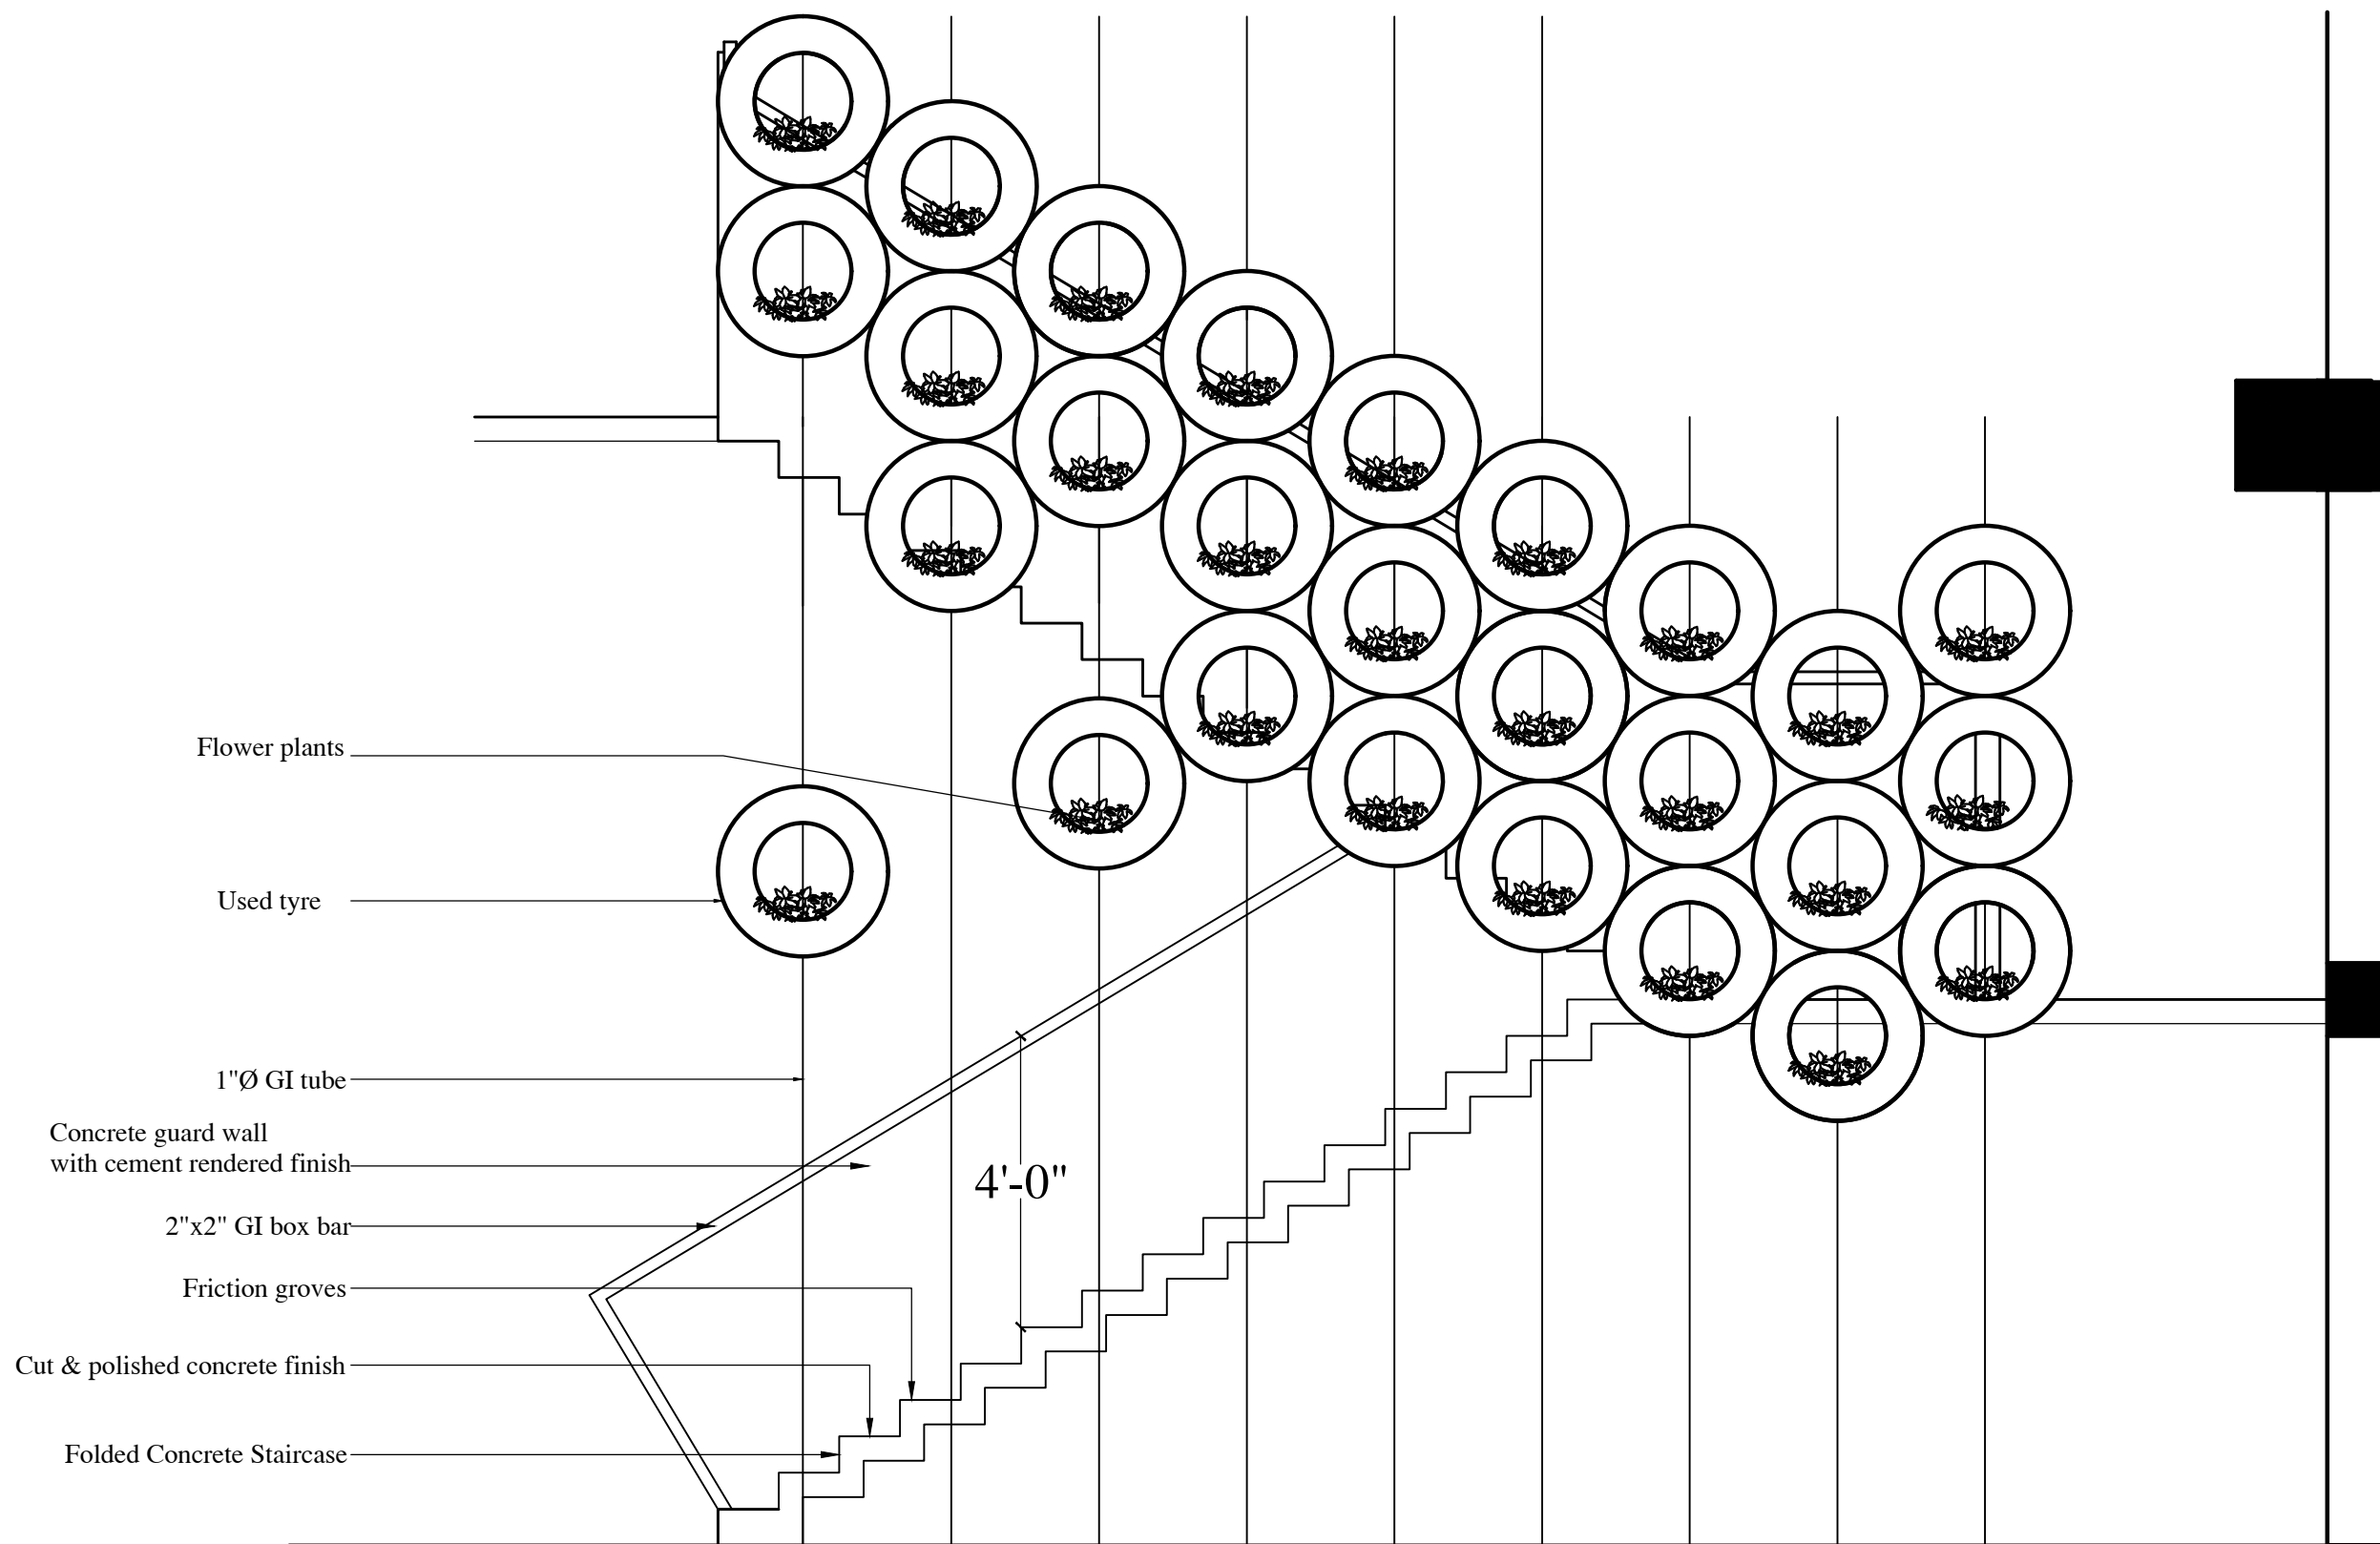

Note: All Dimensions Should be checked at the Site

PROJECT :
 PROPOSED RESEARCH CENTRE FOR
 Ananda Planet Green Force
 At Ananda College
 Colombo 10.


DRAWING TYPE :
 CONSTRUCTION DRAWINGS
 Detail of staircase
 (Ananda Planet Green Force)

CONSULTANT ARCHITECT :
 MUDITHA JAYAKODY ASSOCIATES (PVT.) LTD;
 CHARTERED ARCHITECTS & CONSORTIUM CONSULTANTS.
 NO.212, MAIN HOSPITAL ROAD,
 KIRIBATHGODA.
 PHONE : (0094)12910787 / FAX NO : (0094)12908294
 E-mail : arc.mudithaa@gmail.com


CONSULTANT ENGINEER :

REV.	DATE.	DESCRIPTION	DRAWING NUMBER:	
			MJA/And/A15	
			SCALE :	DATE : 28.05.2024
			NTS	SHEET NO. 15


D:\Ananada college\GnF Planet_Print\15-Print-PlnGnF-Det-staircase-02_A3.dwg

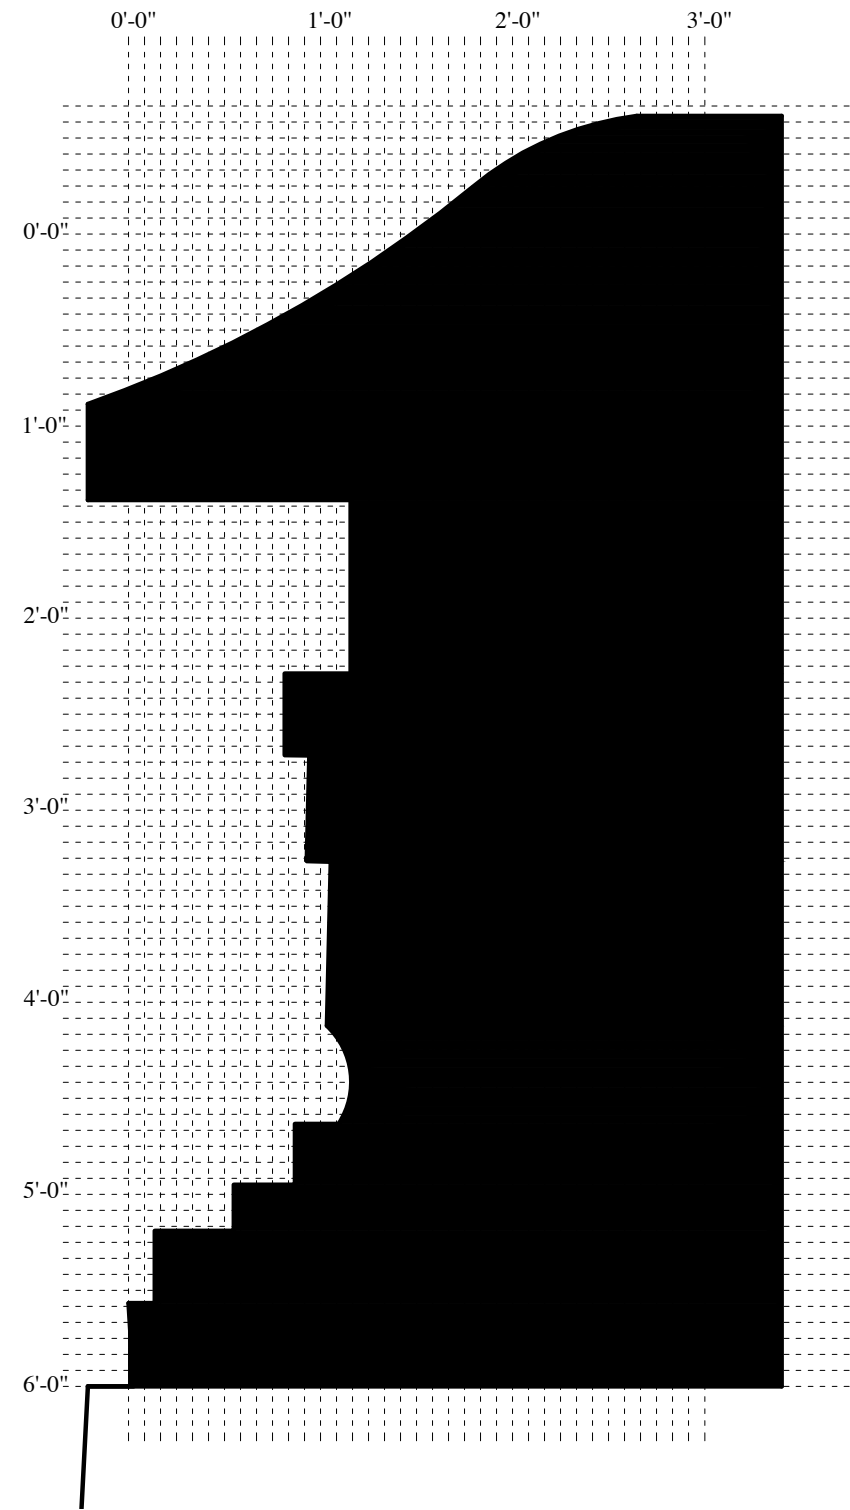

DETAIL - A MOLDING

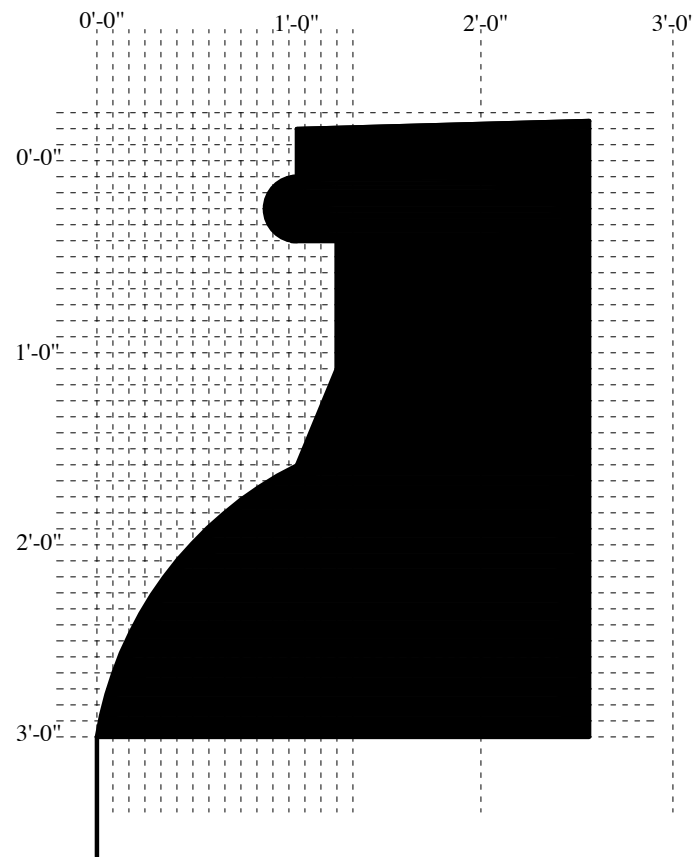


DETAIL - B MOLDING

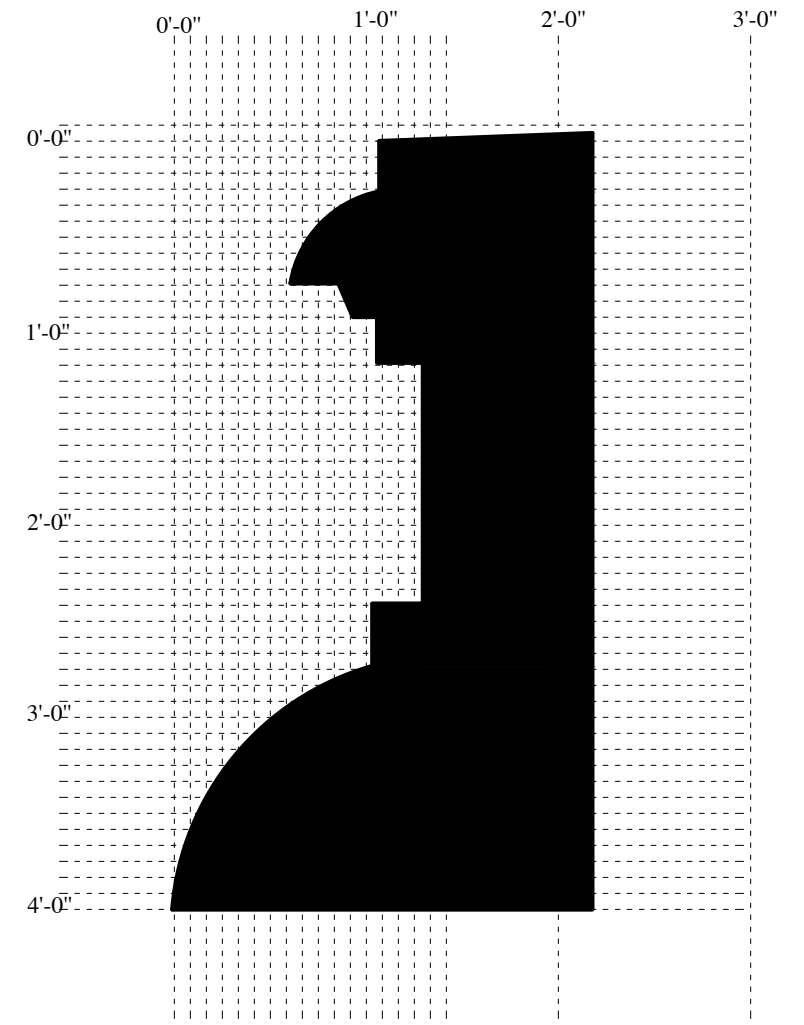


DETAIL - C MOLDING

Note: All Dimensions Should be checked at the Site


PROJECT : PROPOSED RESEARCH CENTRE FOR Ananda Planet Green Force At Ananda College Colombo 10.	DRAWING TYPE : CONSTRUCTION DRAWINGS DETAIL OF MOLDINGS (Sheet -02) (Ananda Planet Green Force)	CONSULTANT ARCHITECT : MUDITHA JAYAKODY ASSOCIATES (PVT.) LTD; CHARTERED ARCHITECTS & CONSORTIUM CONSULTANTS. NO.212, MAIN HOSPITAL ROAD, KIRIBATHGODA. PHONE : (0094)12910787 / FAX NO : (0094)12908294 E-mail : arc.mudithaa@gmail.com	CONSULTANT ENGINEER :	REV.	DATE.	DESCRIPTION	DRAWING NUMBER:
							MJA/And/A16a
							SCALE : DATE : 28.05.2024
							SHEET NO. 16a
				NTS			
D:\Ananada college\GnF Planet_Print\16a-Print-PlnGnF-Det-Molding sheet02_A3.dwg							

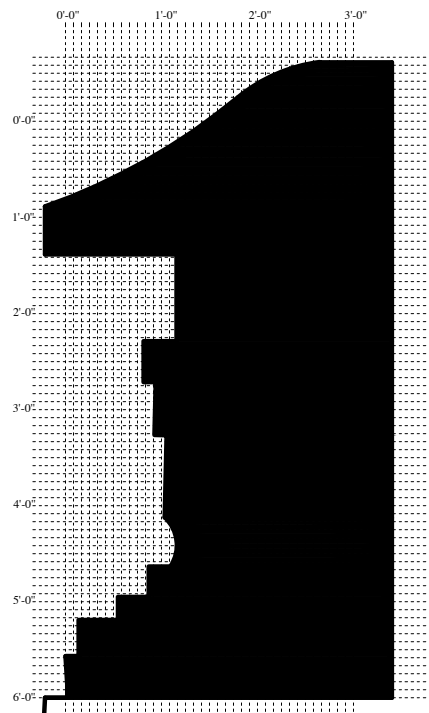


DETAIL - A MOLDING

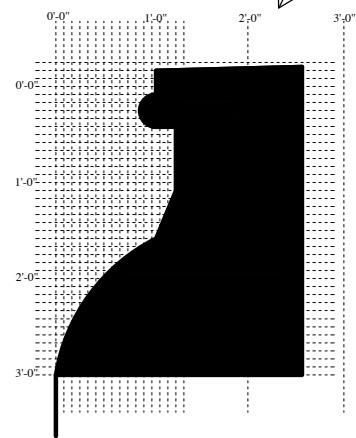

DETAIL - B MOLDING

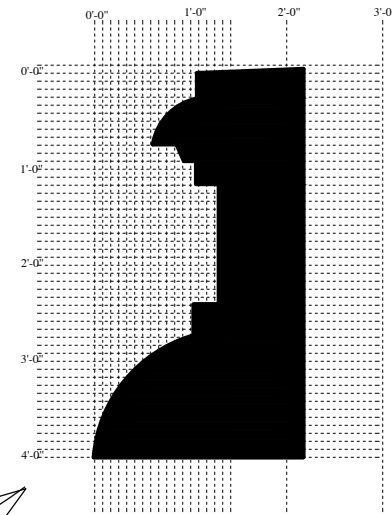

DETAIL - C MOLDING

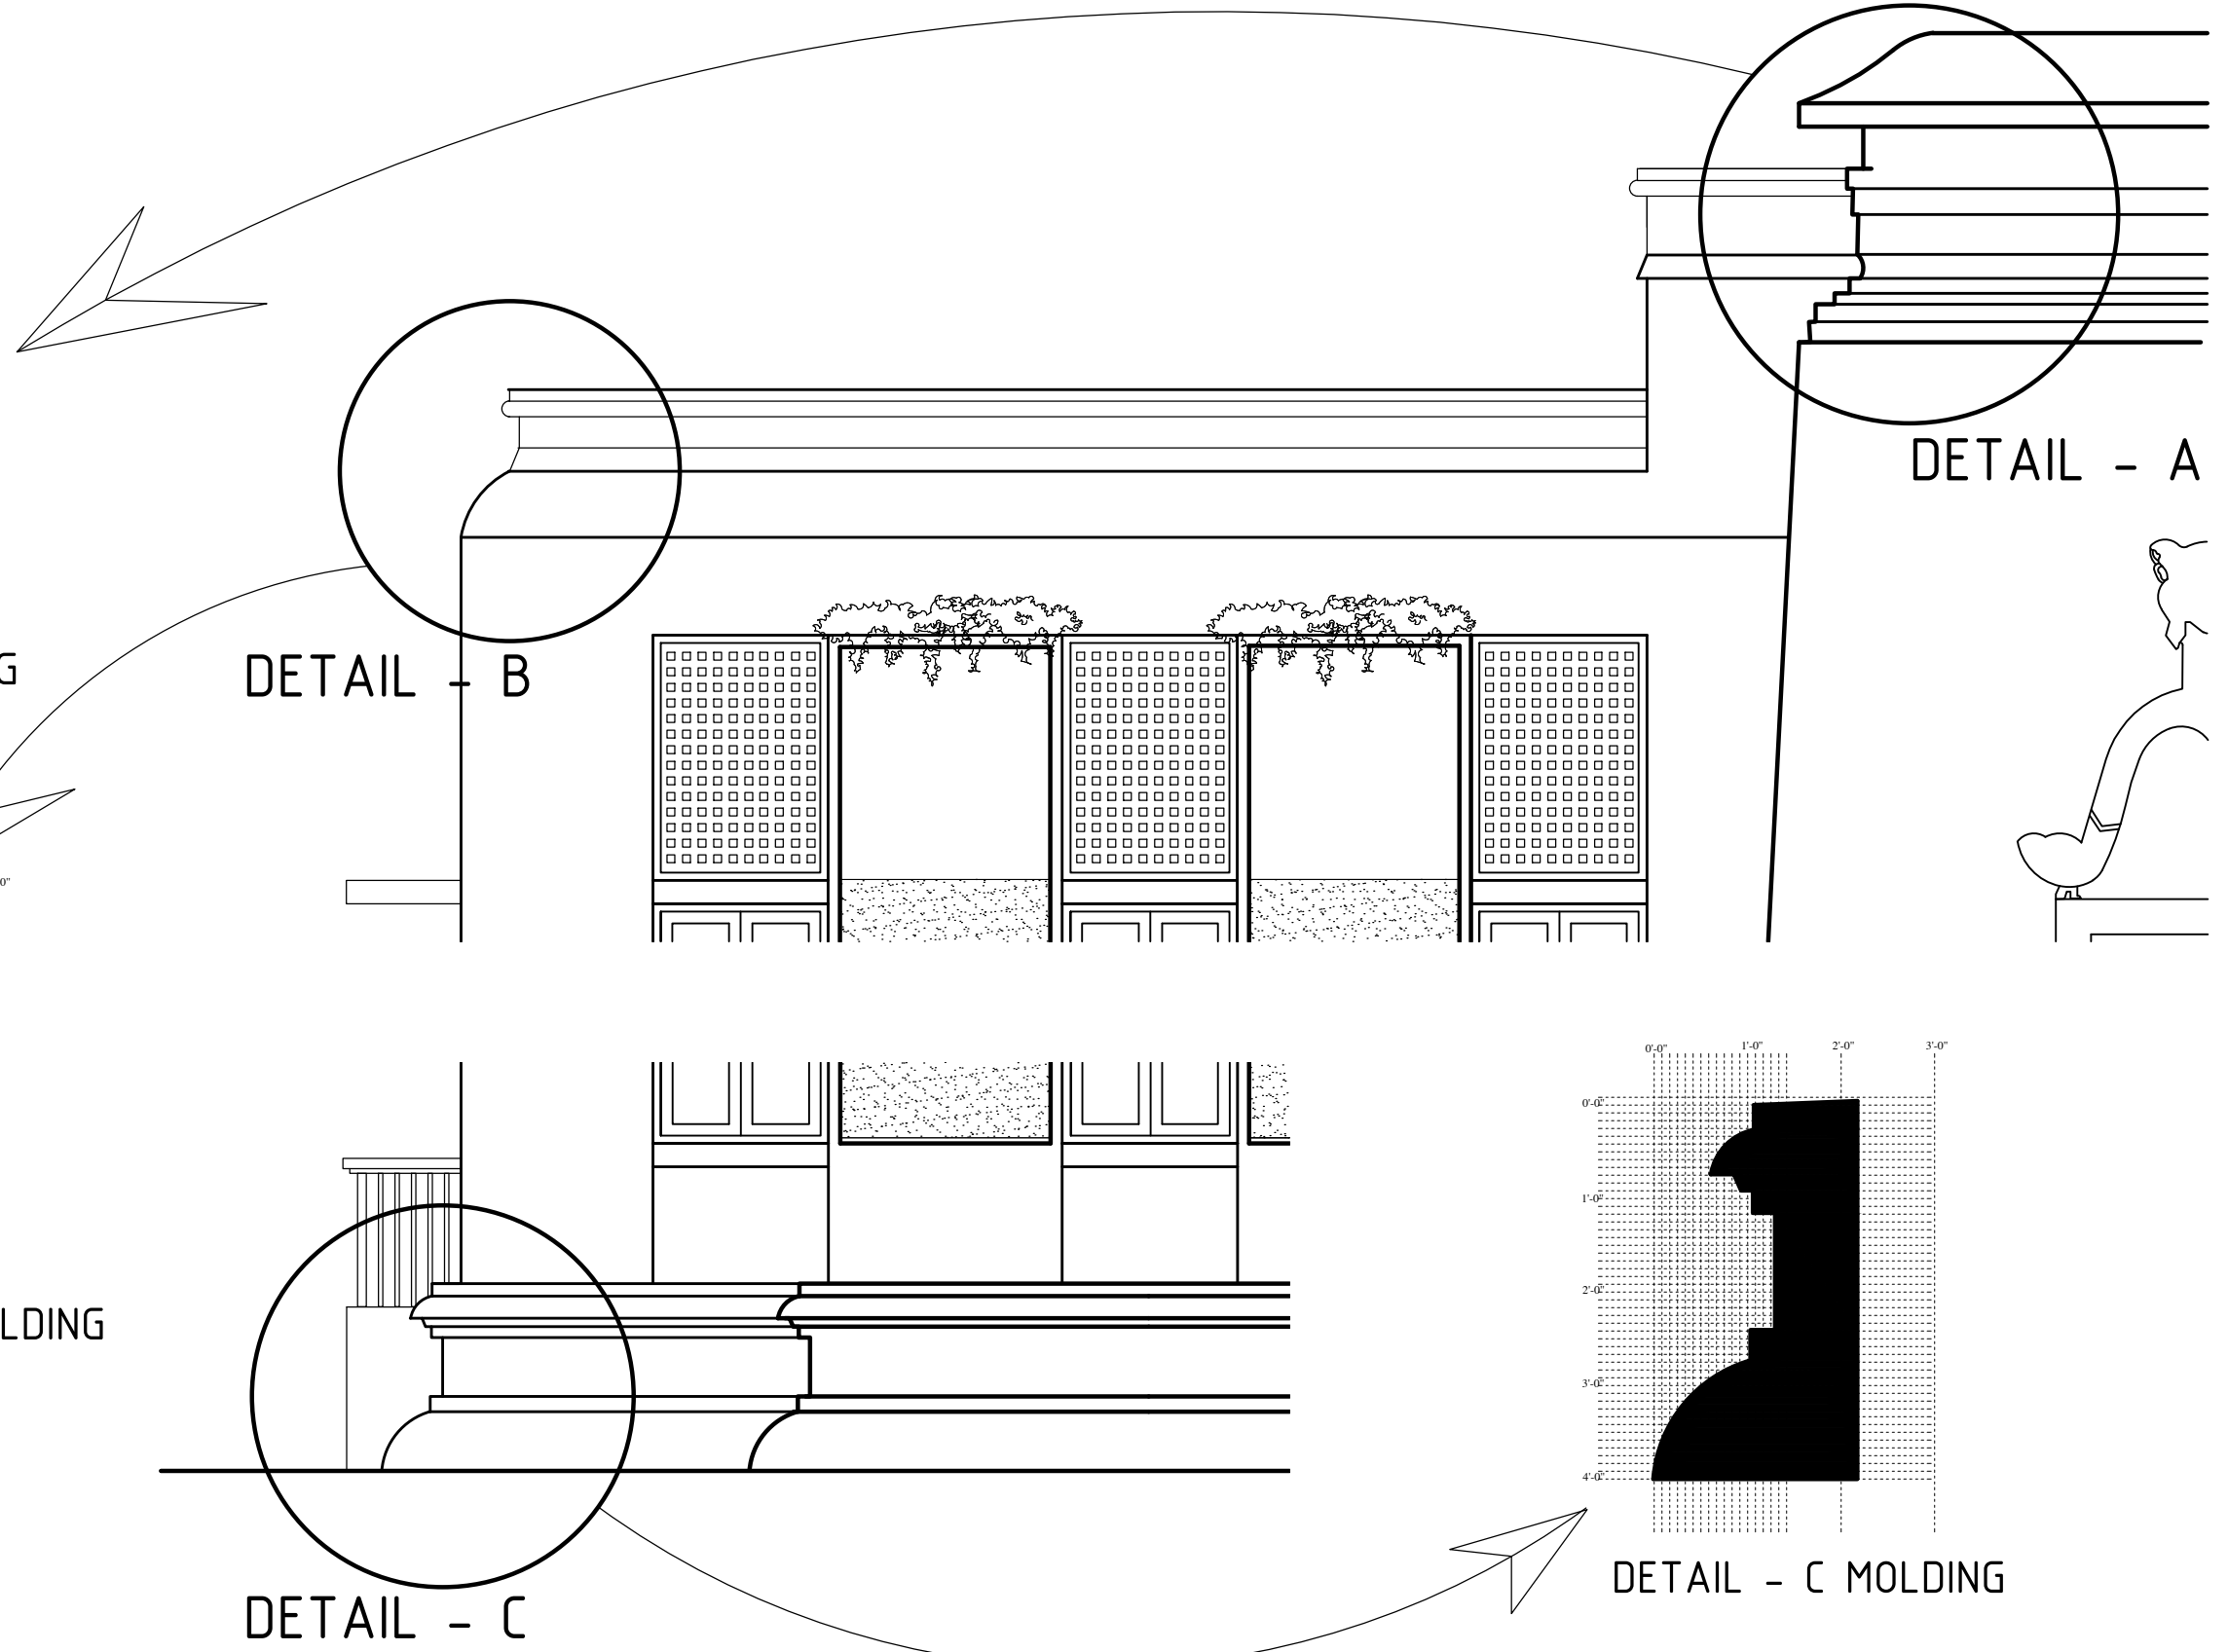





Note: All Dimensions Should be checked at the Site

PROJECT : PROPOSED RESEARCH CENTRE FOR Ananda Planet Green Force At Ananda College Colombo 10.	DRAWING TYPE : CONSTRUCTION DRAWINGS DETAIL OF MOLDINGS (Sheet-01) (Ananda Planet Green Force)	CONSULTANT ARCHITECT : MUDITHA JAYAKODY ASSOCIATES (PVT.) LTD; CHARTERED ARCHITECTS & CONSORTIUM CONSULTANTS. NO.212, MAIN HOSPITAL ROAD, KIRIBATHGODA. PHONE : (0094)12910787 / FAX NO : (0094)12908294 E-mail : arc.mudithaa@gmail.com	CONSULTANT ENGINEER :	REV.	DATE.	DESCRIPTION	DRAWING NUMBER:
							MJA/And/A16
				SCALE :	DATE :	28.05.2024	SHEET NO.
				NTS			16

D:\Ananada college\GnF Planet_Print\16-Print-PlnGnF-Det-Molding sheet01_A3.dwg

	SPACE	AREA	FINISH
01	Exterior wall	Marked as 01	Well selected expose "Kabok" finish
02	Exterior wall	Marked as 02	Semi-rough plaster finish
03	Exterior wall	Other than 01 & 02	Well selected used old brick finish
04	Exterior wall	Plinth	Cement rendered finish
05	Exterior wall	Moulding on "kabok" wall	Semi-rough plaster finish
06	Exterior wall	Moulding on used bricks	carved brick wall & Semi-rough plaster finish
07	Exterior wall	Windowsill & lintel moulding	Neatly done expose concrete finish
08	Exterior wall	Plinth	Cement rendered finish
09	Entrance way	Stairs	Cut & polished concrete
10	Entrance way	Walls	Well selected expose "Kabok" finish
11	Entrance way	Ceiling	Smooth plaster finish
12	Hall of Fame	Walls -Marked as 03	Old roofing tiles
13	Hall of Fame	Walls -Marked as 04	Well selected used old brick finish
14	Hall of Fame	Floor	Cut & polished concrete
15	Hall of Fame	Ceiling	Smooth plaster finish
16	Staircase	Floor	Cut & polished concrete
17	Staircase	Guard wall	Cement render
18	Soil, Aquaponics & Hydroponics Area	Walls	Smooth plaster finish
19	Soil, Aquaponics & Hydroponics Area	Floor	Cut & polished concrete
20	Soil, Aquaponics & Hydroponics Area	Ceiling	Cement render
21	Nature / Living Laboratory	Walls	Smooth plaster finish
22	Nature / Living Laboratory	Floor	Cut & polished concrete
23	Nature / Living Laboratory	Ceiling	Cement render
24	Teaching Kitchen (1st Fl)	Floor	Cut & polished cement render
25	Teaching Kitchen (1st Fl)	Wall (excl. lobby wall)	Smooth plaster finish
26	Teaching Kitchen (1st Fl)	Ceiling	Cement render
27	Lecture Hall (1st Floor)	Wall (excl. lobby wall)	Old door panels
28	Lecture Hall (1st Floor)	Floor	Old timber deck
29	Lecture Hall (1st Floor)	Ceiling	Neatly finished naked soffit covered with old printed book pages
30	Lobby (1st Floor)	Wall	Old roofing tiles
31	Lobby (1st Floor)	Floor	Old timber deck
32	Lobby (1st Floor)	Ceiling	Smooth plaster finish

FINISHING SCHEDULE

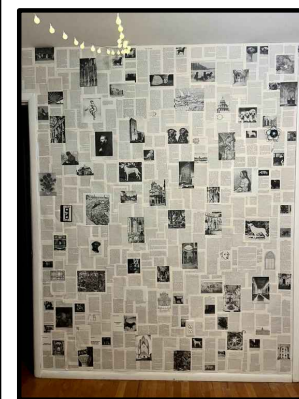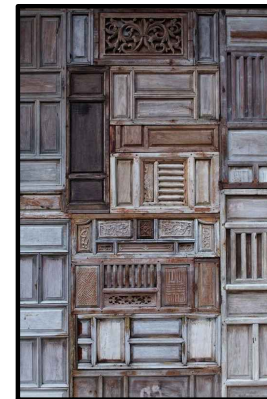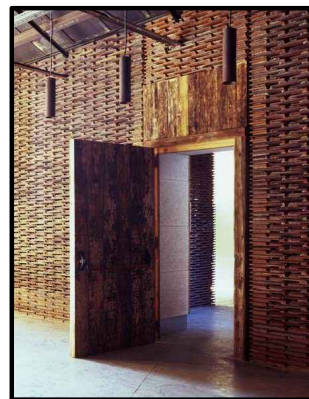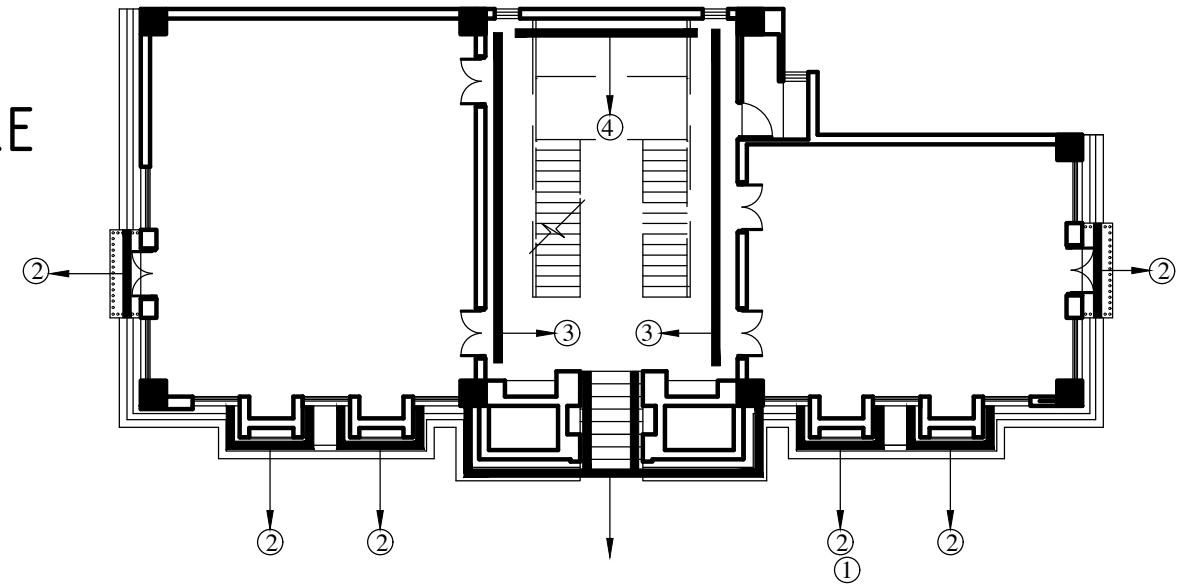

	SPACE	AREA	FINISH
33	Roof slab	Floor	Waterproof with min 10 yrs warranty & cement render
34	Roof slab	walls	Waterproof with min 10 yrs warranty & semi rough plaster finish

Note: All Dimensions Should be checked at the Site

PROJECT :
PROPOSED RESEARCH CENTRE FOR
Ananda Planet Green Force

At Ananda College
Colombo 10.

DRAWING TYPE :
CONSTRUCTION DRAWINGS
Finishing schedule
(Ananda Planet Green Force)

CONSULTANT ARCHITECT :
MUDITHA JAYAKODY ASSOCIATES (PVT.) LTD;
CHARTERED ARCHITECTS & CONSORTIUM CONSULTANTS.
NO.212, MAIN HOSPITAL ROAD,
KIRIBATHGODA.
PHONE : (0094)12910787 / FAX NO : (0094)12908294
E-mail : arc.mudithaa@gmail.com

CONSULTANT ENGINEER :

REV.	DATE.	DESCRIPTION	DRAWING NUMBER.
			MJA/And/A17
			SCALE : DATE : 28.05.2024
			SHEET NO. 17
			NTS

D:\Ananada college\GnF Planet_Print\17-Print-PlnGrF-FiniSchedule-_A3.dwg